







OWNER:  شرکت سست و سویی توسعه ایرانلیان (سهامی عامه)	BUSHEHR PETROCHEMICAL COMPANY MEG PLANT						EPC CONTRACTOR:  Chagalesh-Enerchimi-Steam Joint Venture BUPC-MEG PLANT PROJECT		
	LOOP DIAGRAM FOR NITROGEN GAS BOOSTER								
MC :  شرکت سست و سویی توسعه ایرانلیان (سهامی عامه)	Project	Area	Phase	Unit	Dis.	Doc.	Seq.	Contract No : 52-98/445	
Owner Document Number: 17811-30A	BU	20	VD	303	IN	DIG	0036	Rev.:	Page
								01	1 of 35

LOOP DIAGRAM FOR NITROGEN GAS BOOSTER

 شرکت سست و سویی توسعه ایرانلیان (سهامی عامه)	 Chagalesh-Enerchimi-Steam Joint Venture BUPC-MEG PLANT PROJECT	BUSHEHR PETROCHEMICAL COMPANY MEG PLANT
Document Review		
Issue Purpose:		IFA
Result Code: AP,AN,CM,RE,NC		AP
Next Status : IFC,IFA,IFI,AFC,AB		AFC
Responsible Department		MECHANICAL
Commented Date		7/24/2022
Approval or review hereunder shall not be construed to relieve Vendor / Subcontractor of his responsibilities and liability under the contract.		

01	15/07/2022	For approval	MG	RB	KP	
00	18/10/2021	For approval	HT	KP	JR	
Rev.	Date	Purpose of Issue	Prepared	Checked	Approved	AC Code
					Class: 1	Phase: P



Airpack B.V.

4301 RN Zierikzee
The Netherlands

PHONE: (31) (0) 111 - 415455

FAX: (31) (0) 111 - 413338

E-MAIL : AIRPACK@AIRPACK.NL

WEBPAGE : WWW.AIRPACK.NL

Client : Bushehr Petrochemical Company (BUPC)

Equipment location : Iran, Onshore

Client reference : Bushehr MEG Plant Project

Client dwg. no. : BU-20-VD-303-IN-DIG-0043

Airpack reference : 17811-30A

Airpack dwg. no. : 17811-05

Generation date : 6-11-2020

E & I manager : RBE

Last modifications : 14-7-2022


Last modifications by : MaGo

Revision no. : 01




CLIENT DWG NO.	BU-20-VD-303-IN-DIG-0043	SUBJECT		DRAWN BY	MaGo	=
EQUIPMENT NO.	20-C-1002	Title page / cover sheet		CHECKED BY	RBE	+
EQUIPMENT LOCATION	Iran, Onshore	ADAPTED TO P&ID REVISION	05	LAST MODIFICATION DATE		CURRENT PAGE
THIS DRAWING IS OWNED BY AIRPACK, AND SHALL NOT BE PRINTED OR COPIED IN ANY OTHER WAY THAN WITH AIRPACKS PERMISSION!		CLIENT	Bushehr Petrochemical Company (BUPC)	AIRPACK DWG NO.	17811-05	
		CLIENT REF.	Bushehr MEG Plant Project	REVISION	01	
		AIRPACK REF.	17811-30A	TOTAL PAGE AMOUNT	1	


Internal targets

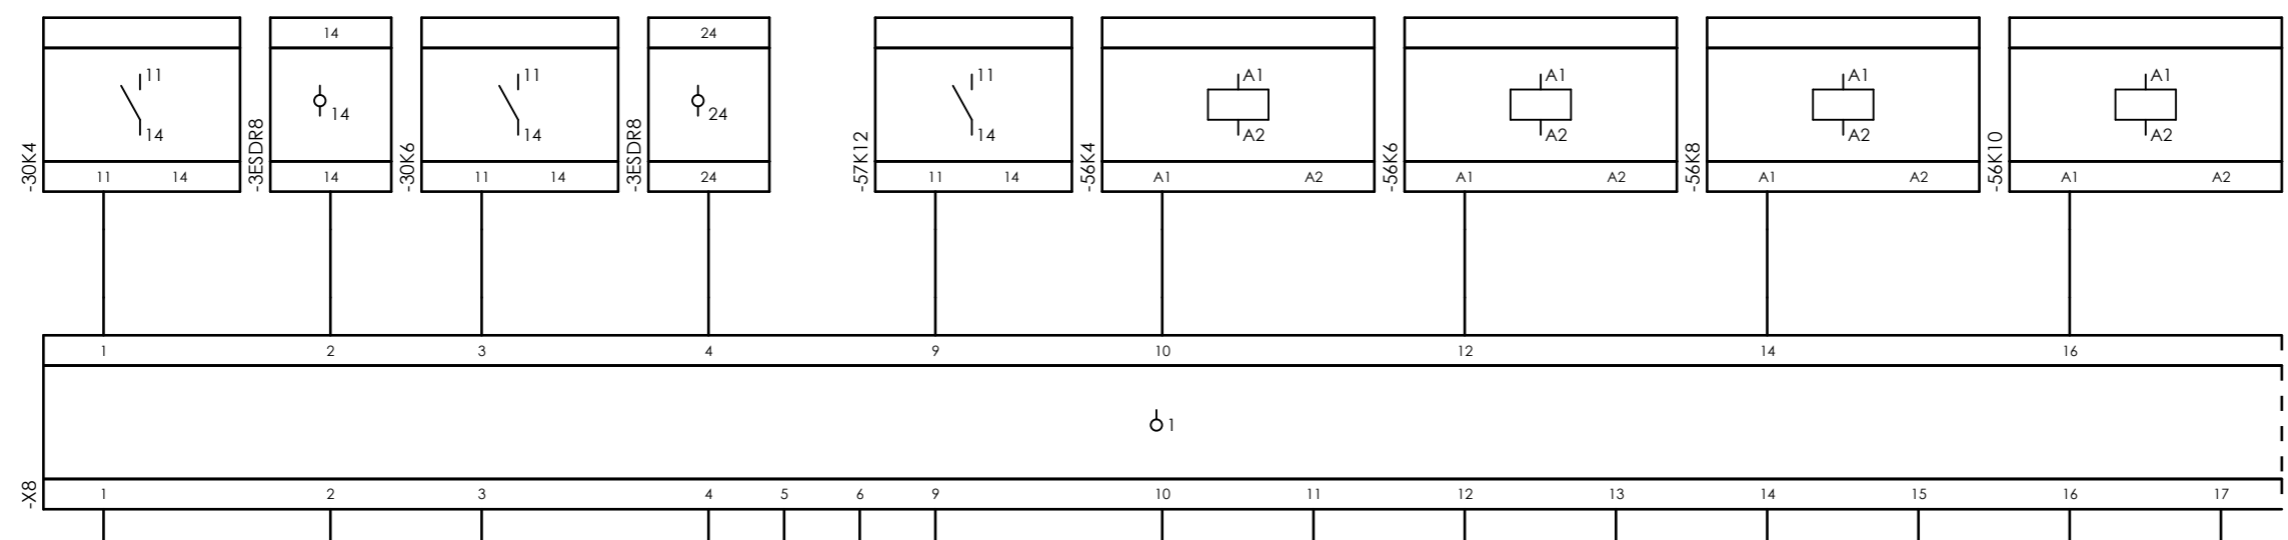

=20-C-1002+UCP-C1002-01-DB_COMA

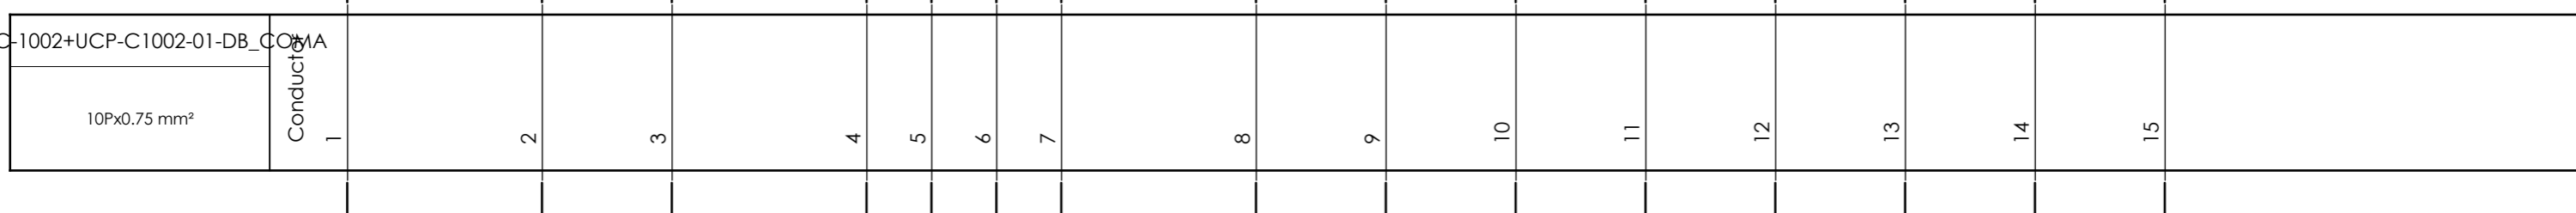

External targets

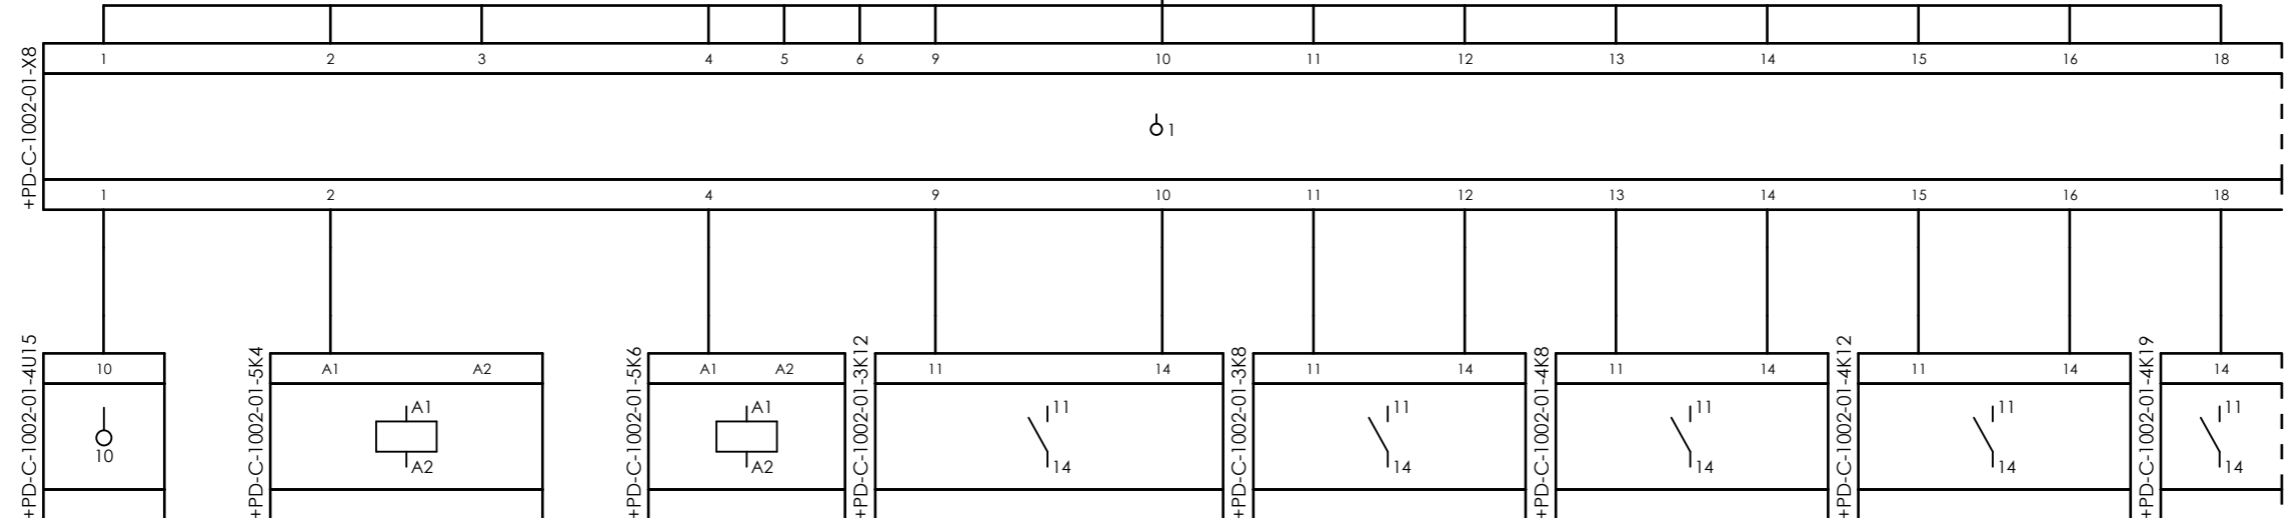


CLIENT DWG NO.	BU-20-VD-303-IN-DIG-0043	SUBJECT	Cable-connection diagram =20-C-1002+UCP-C1002-01-DB_COMA
EQUIPMENT NO.	20-C-1002	ADAPTED TO P&ID REVISION	05
EQUIPMENT LOCATION	Iran, Onshore	CLIENT	Bushehr Petrochemical Company (BUPC)
THIS DRAWING IS OWNED BY AIRPACK, AND SHALL NOT BE PRINTED OR COPIED IN ANY OTHER WAY THAN WITH AIRPACKS PERMISSION!	CLIENT REF.	CLIENT REF.	Bushehr MEG Plant Project
	AIRPACK REF.	AIRPACK REF.	17811-30A

DRAWN BY	MaGo
CHECKED BY	RBE
LAST MODIFICATION DATE	
AIRPACK DWG NO.	17811-05
REVISION	01
TOTAL PAGE AMOUNT	2

=	
+	
	CURRENT PAGE


Internal targets

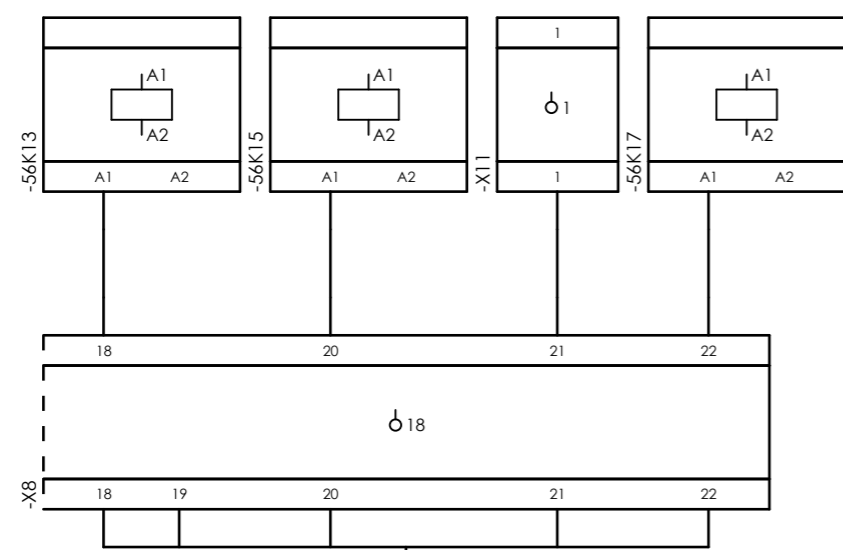

=20-C-1002+UCP-C1002-01-DB_COMA



External targets

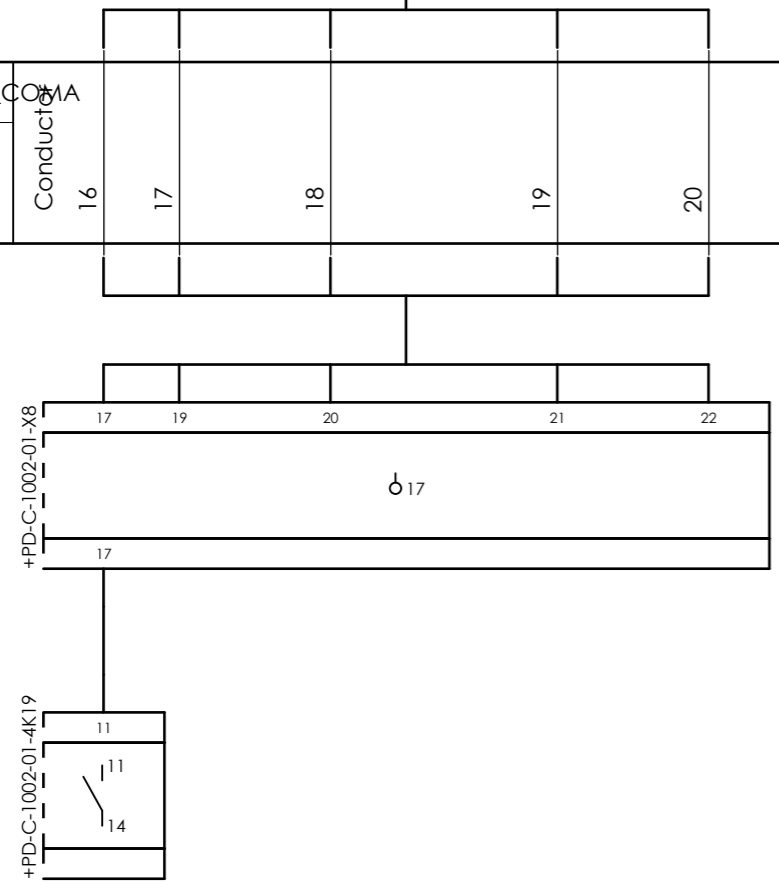


CLIENT DWG NO. BU-20-VD-303-IN-DIG-0043
 EQUIPMENT NO. 20-C-1002
 EQUIPMENT LOCATION Iran, Onshore
 THIS DRAWING IS OWNED BY AIRPACK, AND SHALL NOT BE PRINTED OR COPIED IN ANY OTHER WAY THAN WITH AIRPACKS PERMISSION!

SUBJECT Cable-connection diagram =20-C-1002+UCP-C1002-01-DB_COMA
 ADAPTED TO P&ID REVISION 05
 CLIENT Bushehr Petrochemical Company (BUPC)
 CLIENT REF. Bushehr MEG Plant Project
 AIRPACK REF. 17811-30A

DRAWN BY MaGo
 CHECKED BY RBE
 LAST MODIFICATION DATE
 AIRPACK DWG NO. 17811-05
 REVISION 01
 TOTAL PAGE AMOUNT 3


=
 +
 CURRENT PAGE
 3

Internal targets


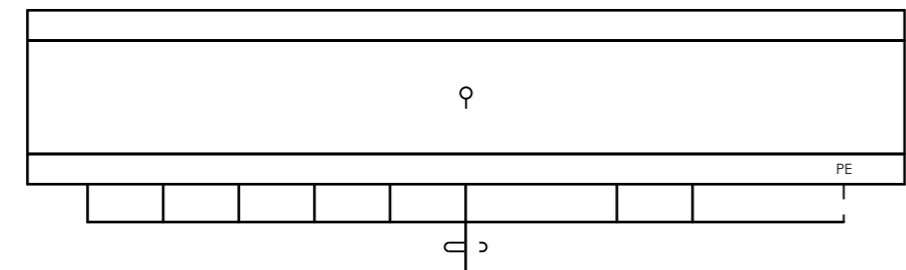


=20-C-1002+UCP-C1002-01-ESD

5Px0.75 mm² mm²

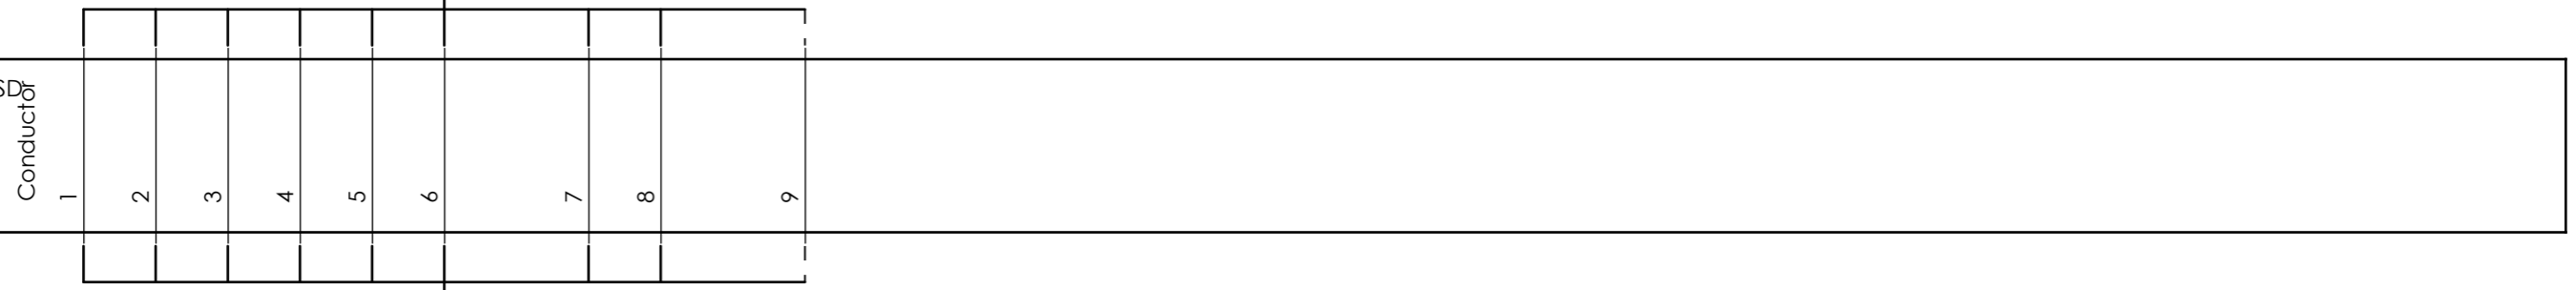

External targets

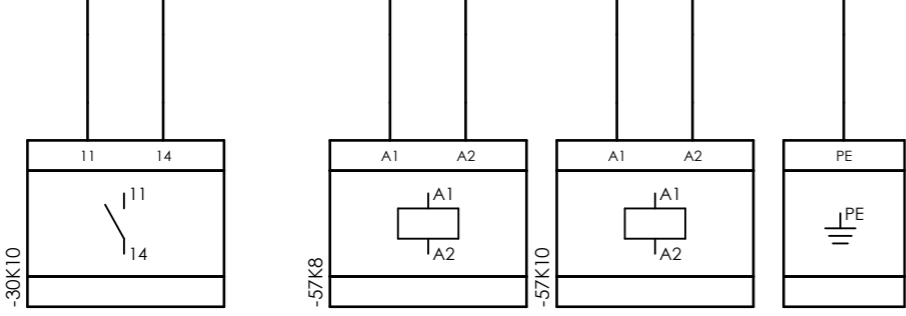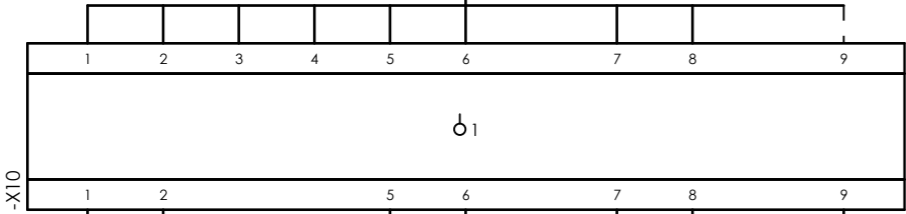


THIS DRAWING IS OWNED BY AIRPACK, AND SHALL NOT BE PRINTED OR COPIED IN ANY OTHER WAY THAN WITH AIRPACKS PERMISSION!


CLIENT DWG NO.	BU-20-VD-303-IN-DIG-0043	SUBJECT	Cable-connection diagram =20-C-1002+UCP-C1002-01-ESD
EQUIPMENT NO.	20-C-1002	ADAPTED TO P&ID REVISION	05
EQUIPMENT LOCATION	Iran, Onshore	CLIENT	Bushehr Petrochemical Company (BUPC)
		CLIENT REF.	Bushehr MEG Plant Project
		AIRPACK REF.	17811-30A

DRAWN BY	MaGo	=
CHECKED BY	RBE	+
LAST MODIFICATION DATE		CURRENT PAGE
AIRPACK DWG NO.	17811-05	
REVISION	01	
TOTAL PAGE AMOUNT	4	

Internal targets





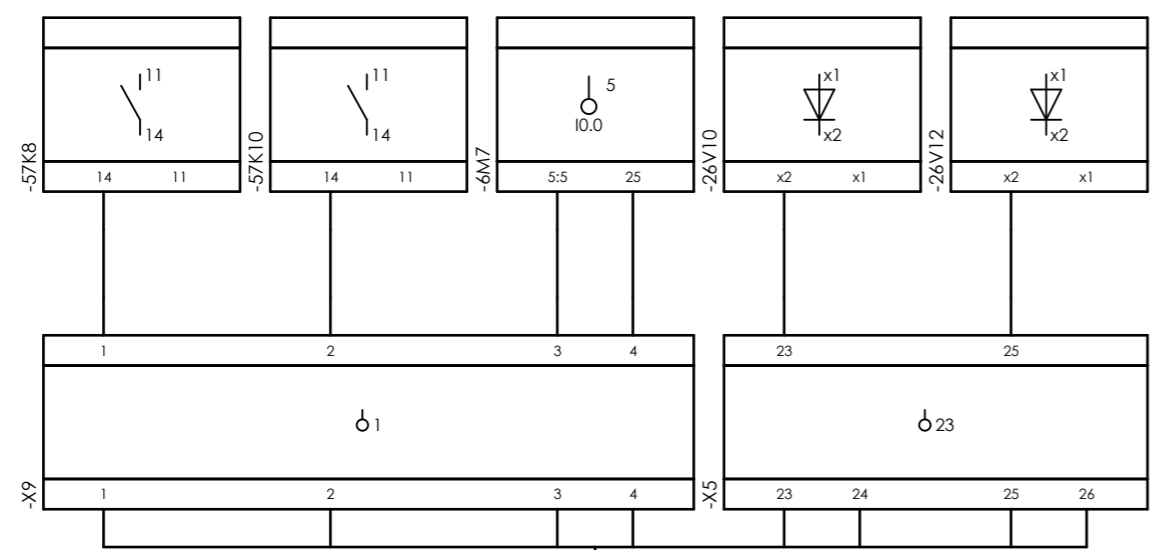


External targets

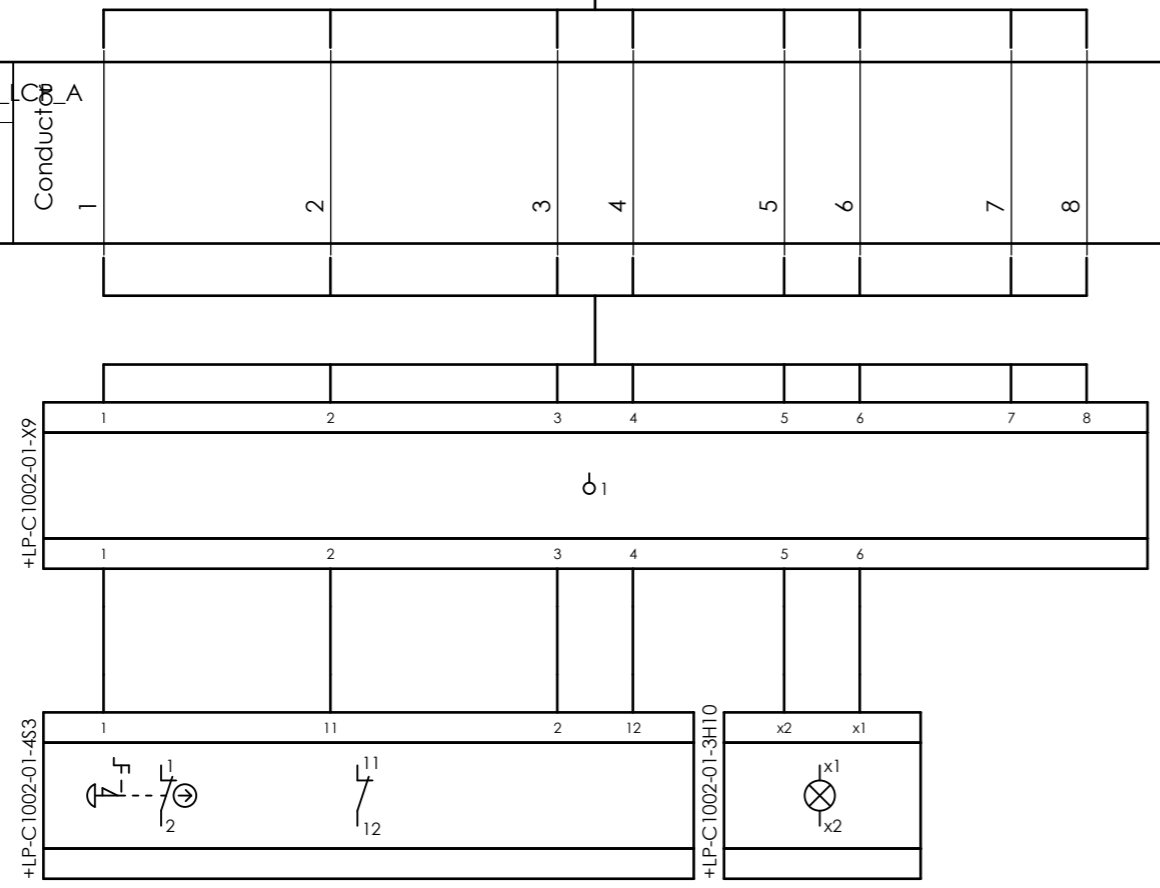

CLIENT DWG NO.	BU-20-VD-303-IN-DIG-0043	SUBJECT		DRAWN BY	MaGo	=
EQUIPMENT NO.	20-C-1002	Cable-connection diagram =20-C-1002+UCP-C1002-01-ESD_LCP_A		CHECKED BY	RBE	+
EQUIPMENT LOCATION	Iran, Onshore	ADAPTED TO P&ID REVISION	05	LAST MODIFICATION DATE		CURRENT PAGE
THIS DRAWING IS OWNED BY AIRPACK, AND SHALL NOT BE PRINTED OR COPIED IN ANY OTHER WAY THAN WITH AIRPACKS PERMISSION!		CLIENT	Bushehr Petrochemical Company (BUPC)	AIRPACK DWG NO.	17811-05	
		CLIENT REF.	Bushehr MEG Plant Project	REVISION	01	
		AIRPACK REF.	17811-30A	TOTAL PAGE AMOUNT	5	

Internal targets

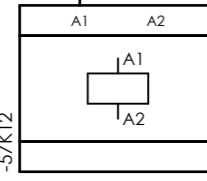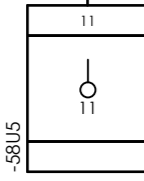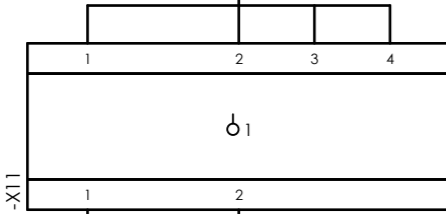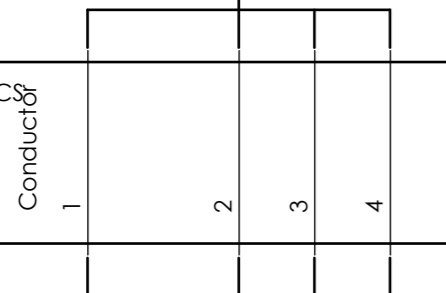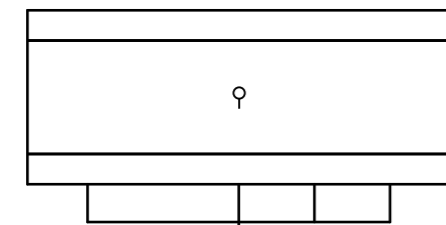

External targets

=20-C-1002+UCP-C1002-01-FCS




CLIENT DWG NO.	BU-20-VD-303-IN-DIG-0043
EQUIPMENT NO.	20-C-1002
EQUIPMENT LOCATION	Iran, Onshore
THIS DRAWING IS OWNED BY AIRPACK, AND SHALL NOT BE PRINTED OR COPIED IN ANY OTHER WAY THAN WITH AIRPACKS PERMISSION!	

SUBJECT		Cable-connection diagram =20-C-1002+UCP-C1002-01-FCS	
ADAPTED TO P&ID REVISION	05	CLIENT	Bushehr Petrochemical Company (BUPC)
CLIENT REF.	Bushehr MEG Plant Project	AIRPACK REF.	17811-30A


DRAWN BY	MaGo
CHECKED BY	RBE
LAST MODIFICATION DATE	
AIRPACK DWG NO.	17811-05
REVISION	01
TOTAL PAGE AMOUNT	6

=	
+	
CURRENT PAGE	

Internal targets

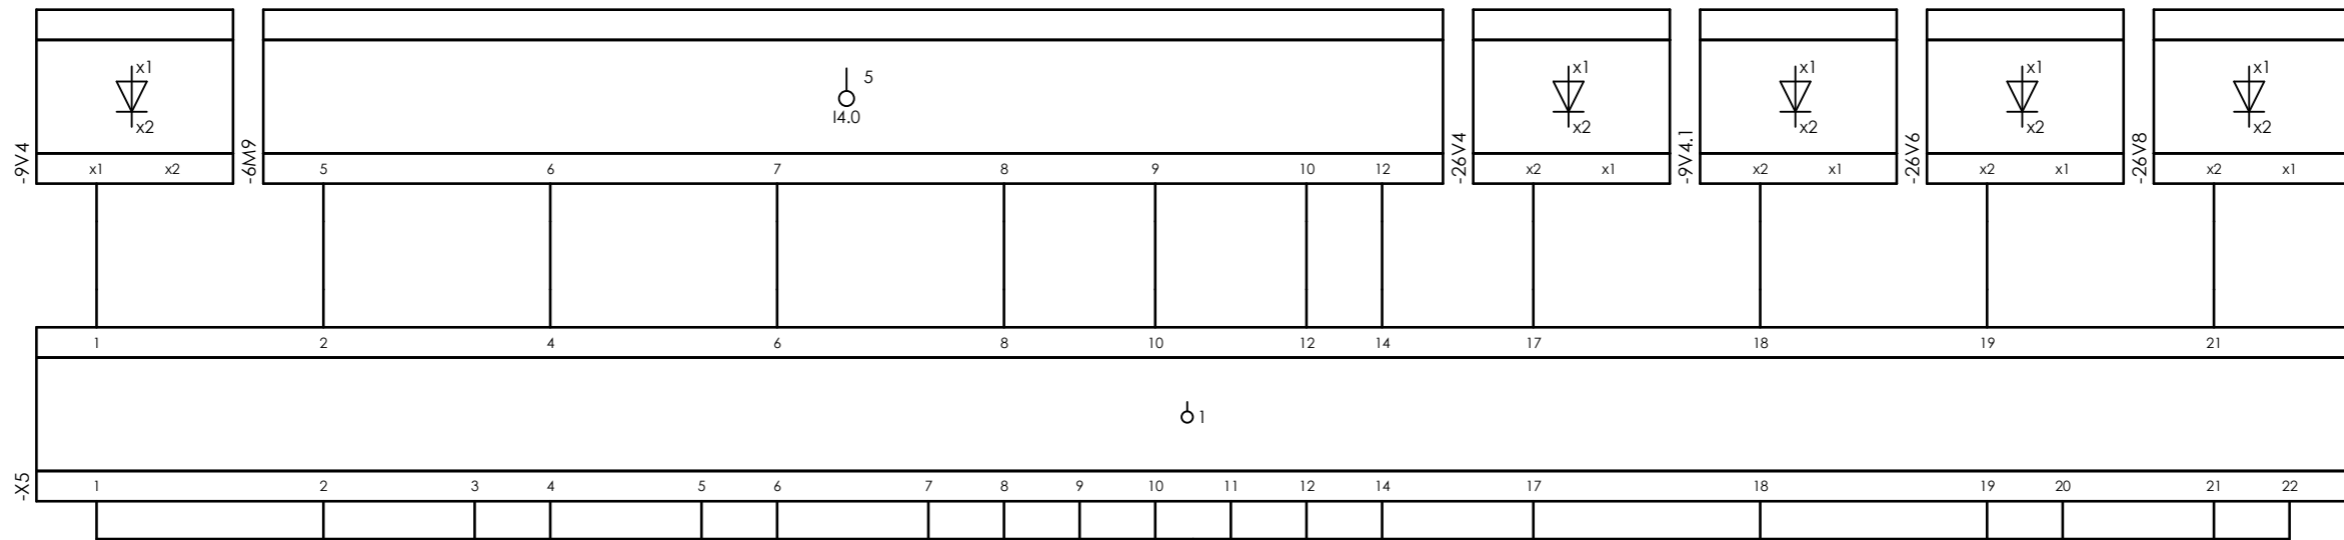

External targets

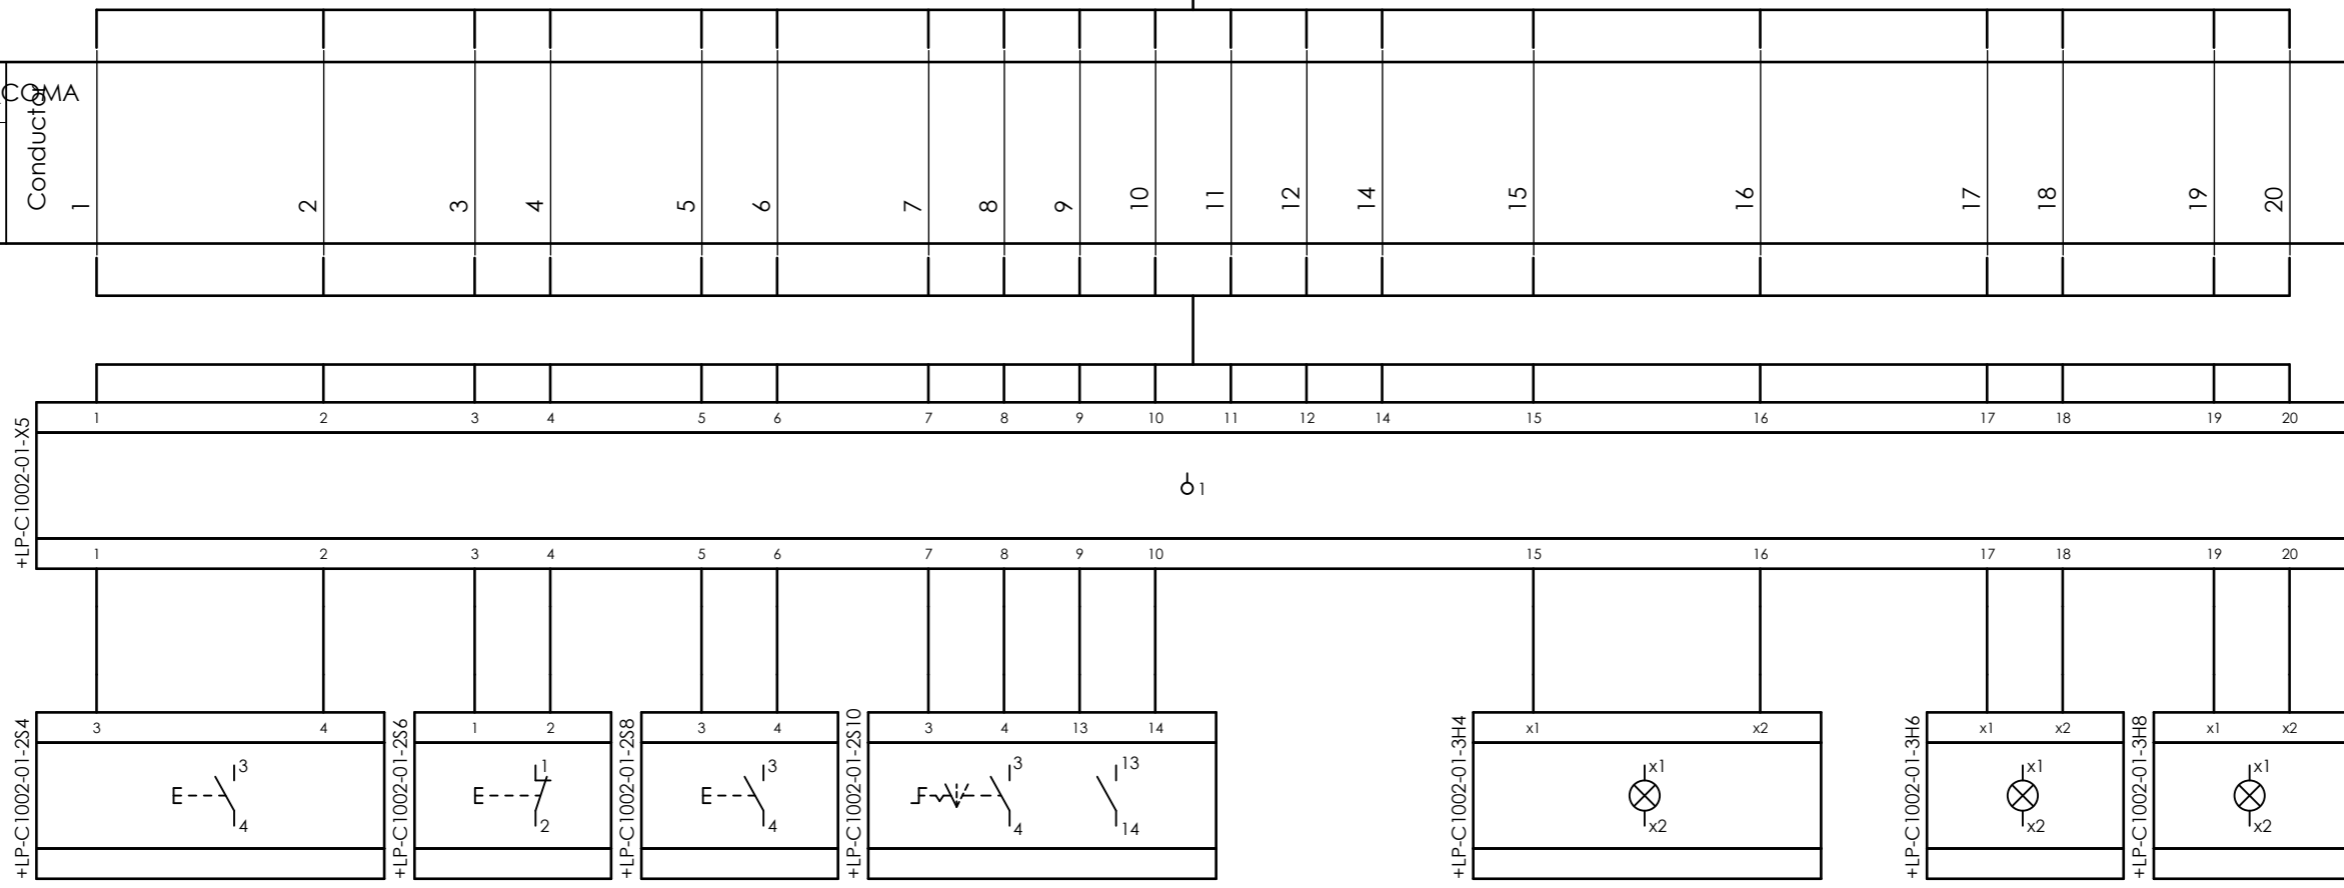


CLIENT DWG NO. BU-20-VD-303-IN-DIG-0043
 EQUIPMENT NO. 20-C-1002
 EQUIPMENT LOCATION Iran, Onshore
 THIS DRAWING IS OWNED BY AIRPACK, AND SHALL NOT BE PRINTED OR COPIED IN ANY OTHER WAY THAN WITH AIRPACKS PERMISSION!

SUBJECT Cable-connection diagram =20-C-1002+UCP-C1002-01-LCP_COMA
 ADAPTED TO P&ID REVISION 05
 CLIENT Bushehr Petrochemical Company (BUPC)
 CLIENT REF. Bushehr MEG Plant Project
 AIRPACK REF. 17811-30A

DRAWN BY MaGo
 CHECKED BY RBE
 LAST MODIFICATION DATE
 AIRPACK DWG NO. 17811-05
 REVISION 01
 TOTAL PAGE AMOUNT 7

=
 +
 CURRENT PAGE
 7


Internal targets

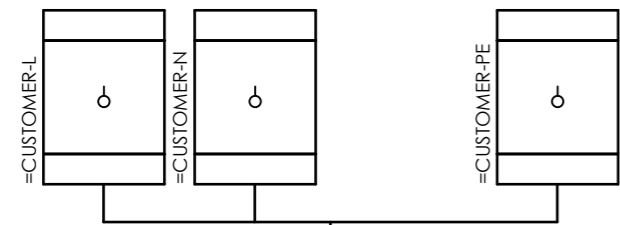

=20-C-1002+UCP-C1002-01-PS_00



External targets

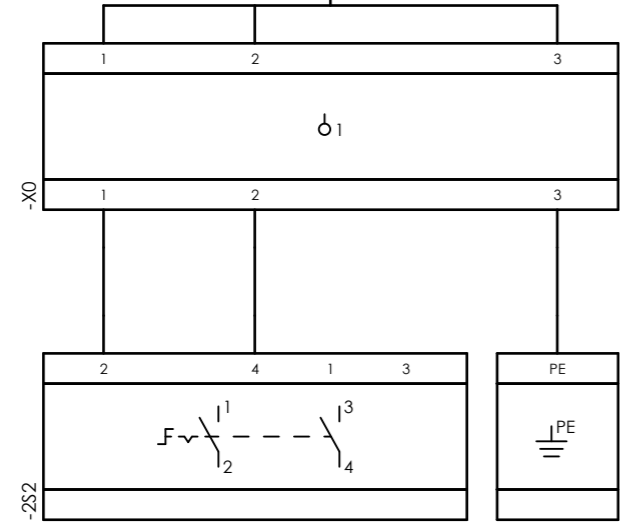


CLIENT DWG NO.	BU-20-VD-303-IN-DIG-0043
EQUIPMENT NO.	20-C-1002
EQUIPMENT LOCATION	Iran, Onshore
THIS DRAWING IS OWNED BY AIRPACK, AND SHALL NOT BE PRINTED OR COPIED IN ANY OTHER WAY THAN WITH AIRPACKS PERMISSION!	

SUBJECT		Cable-connection diagram =20-C-1002+UCP-C1002-01-PS_00	
ADAPTED TO P&ID REVISION	05	CLIENT	Bushehr Petrochemical Company (BUPC)
CLIENT REF.	Bushehr MEG Plant Project	AIRPACK REF.	17811-30A

DRAWN BY	MaGo
CHECKED BY	RBE
LAST MODIFICATION DATE	
AIRPACK DWG NO.	17811-05
REVISION	01
TOTAL PAGE AMOUNT	8

=	
+	
CURRENT PAGE	


Internal targets

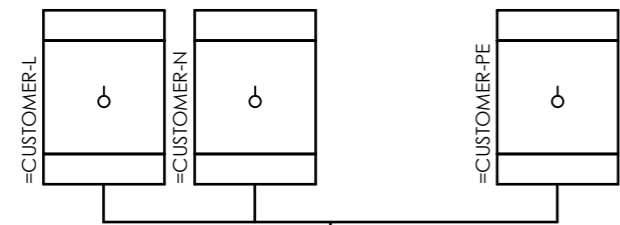

=20-C-1002+UCP-C1002-01-PS_01



External targets

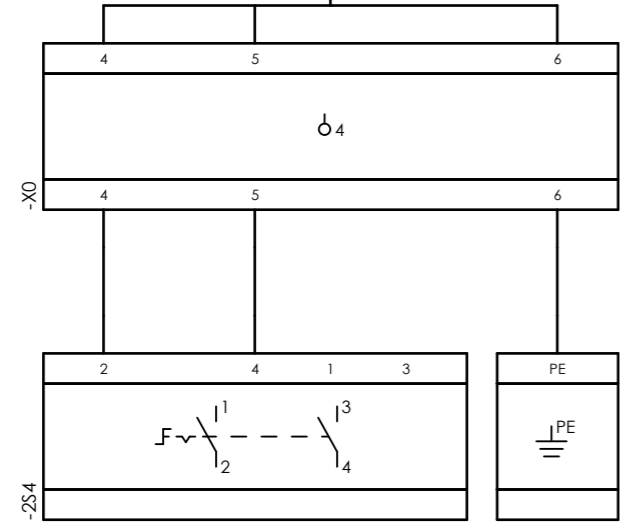


CLIENT DWG NO.	BU-20-VD-303-IN-DIG-0043
EQUIPMENT NO.	20-C-1002
EQUIPMENT LOCATION	Iran, Onshore
THIS DRAWING IS OWNED BY AIRPACK, AND SHALL NOT BE PRINTED OR COPIED IN ANY OTHER WAY THAN WITH AIRPACKS PERMISSION!	

SUBJECT		Cable-connection diagram =20-C-1002+UCP-C1002-01-PS_01	
ADAPTED TO P&ID REVISION	05	CLIENT	Bushehr Petrochemical Company (BUPC)
CLIENT REF.	Bushehr MEG Plant Project	AIRPACK REF.	17811-30A


DRAWN BY	MaGo
CHECKED BY	RBE
LAST MODIFICATION DATE	
AIRPACK DWG NO.	17811-05
REVISION	01
TOTAL PAGE AMOUNT	9

=	
+	
CURRENT PAGE	


Internal targets

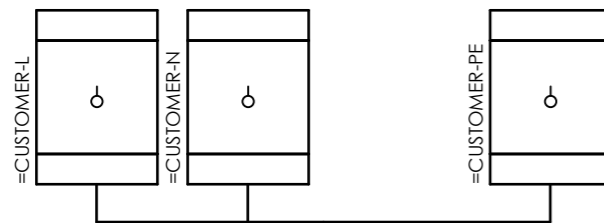

=20-C-1002+UCP-C1002-01-PS_02
3x2.5 sqmm

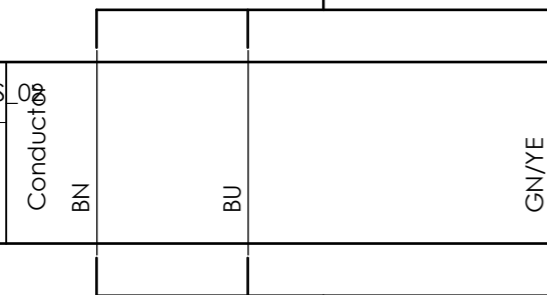

External targets

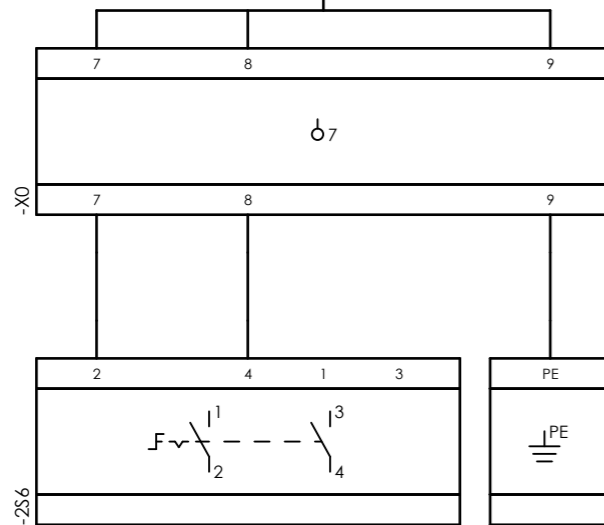


CLIENT DWG NO.	BU-20-VD-303-IN-DIG-0043
EQUIPMENT NO.	20-C-1002
EQUIPMENT LOCATION	Iran, Onshore
THIS DRAWING IS OWNED BY AIRPACK, AND SHALL NOT BE PRINTED OR COPIED IN ANY OTHER WAY THAN WITH AIRPACKS PERMISSION!	

SUBJECT Cable-connection diagram =20-C-1002+UCP-C1002-01-PS_02	
ADAPTED TO P&ID REVISION	05
CLIENT	Bushehr Petrochemical Company (BUPC)
CLIENT REF.	Bushehr MEG Plant Project
AIRPACK REF.	17811-30A

DRAWN BY	MaGo
CHECKED BY	RBE
LAST MODIFICATION DATE	
AIRPACK DWG NO.	17811-05
REVISION	01
TOTAL PAGE AMOUNT	10

=	
+	
CURRENT PAGE	

Internal targets

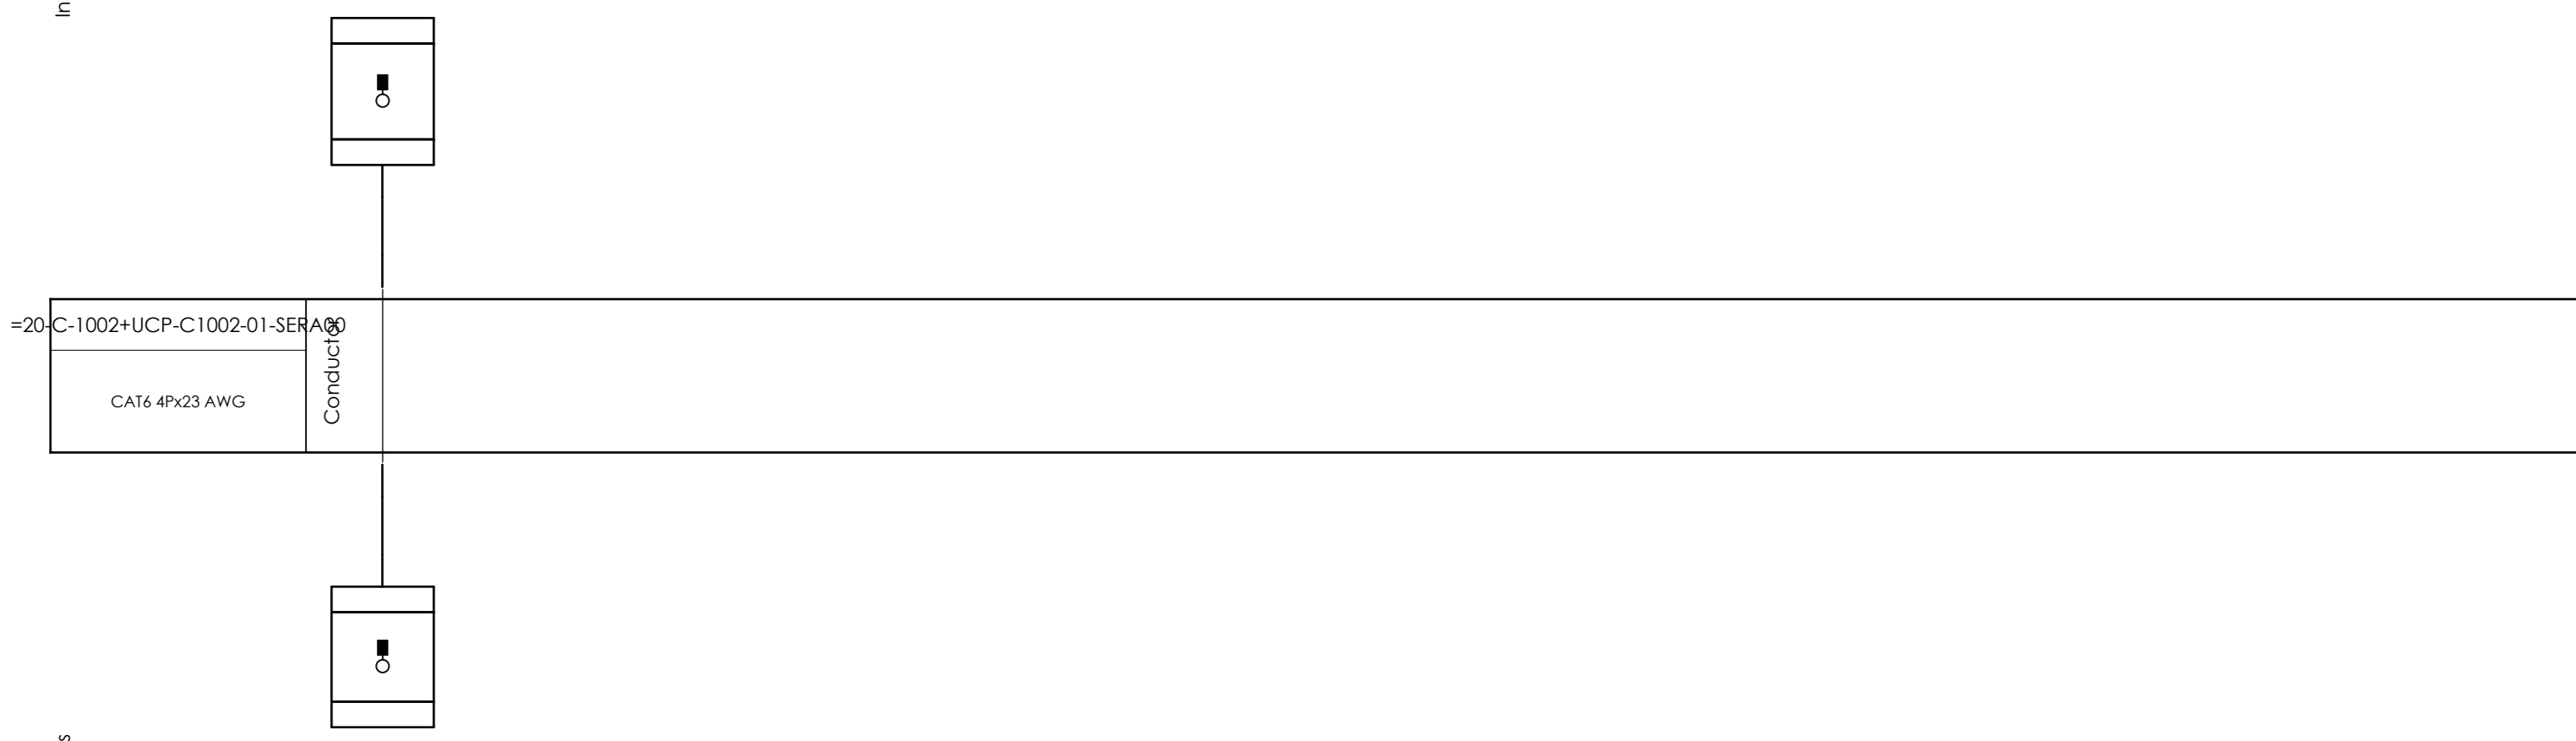

External targets



CLIENT DWG NO.	BU-20-VD-303-IN-DIG-0043
EQUIPMENT NO.	20-C-1002
EQUIPMENT LOCATION	Iran, Onshore
THIS DRAWING IS OWNED BY AIRPACK, AND SHALL NOT BE PRINTED OR COPIED IN ANY OTHER WAY THAN WITH AIRPACKS PERMISSION!	

SUBJECT		Cable-connection diagram =20-C-1002+UCP-C1002-01-SERA00	
ADAPTED TO P&ID REVISION	05	CLIENT	Bushehr Petrochemical Company (BUPC)
CLIENT REF.	Bushehr MEG Plant Project	AIRPACK REF.	17811-30A

DRAWN BY	MaGo
CHECKED BY	RBE
LAST MODIFICATION DATE	
AIRPACK DWG NO.	17811-05
REVISION	01
TOTAL PAGE AMOUNT	11

=	
+	
CURRENT PAGE	

Internal targets




External targets




CLIENT DWG NO.	BU-20-VD-303-IN-DIG-0043	SUBJECT		DRAWN BY	MaGo	=
EQUIPMENT NO.	20-C-1002	Cable-connection diagram =20-C-1002+UCP-C1002-01-SERA01		CHECKED BY	RBE	+
EQUIPMENT LOCATION	Iran, Onshore	ADAPTED TO P&ID REVISION	05	LAST MODIFICATION DATE		CURRENT PAGE
THIS DRAWING IS OWNED BY AIRPACK, AND SHALL NOT BE PRINTED OR COPIED IN ANY OTHER WAY THAN WITH AIRPACKS PERMISSION!		CLIENT	Bushehr Petrochemical Company (BUPC)	AIRPACK DWG NO.	17811-05	
		CLIENT REF.	Bushehr MEG Plant Project	REVISION	01	
		AIRPACK REF.	17811-30A	TOTAL PAGE AMOUNT	12	

Internal targets

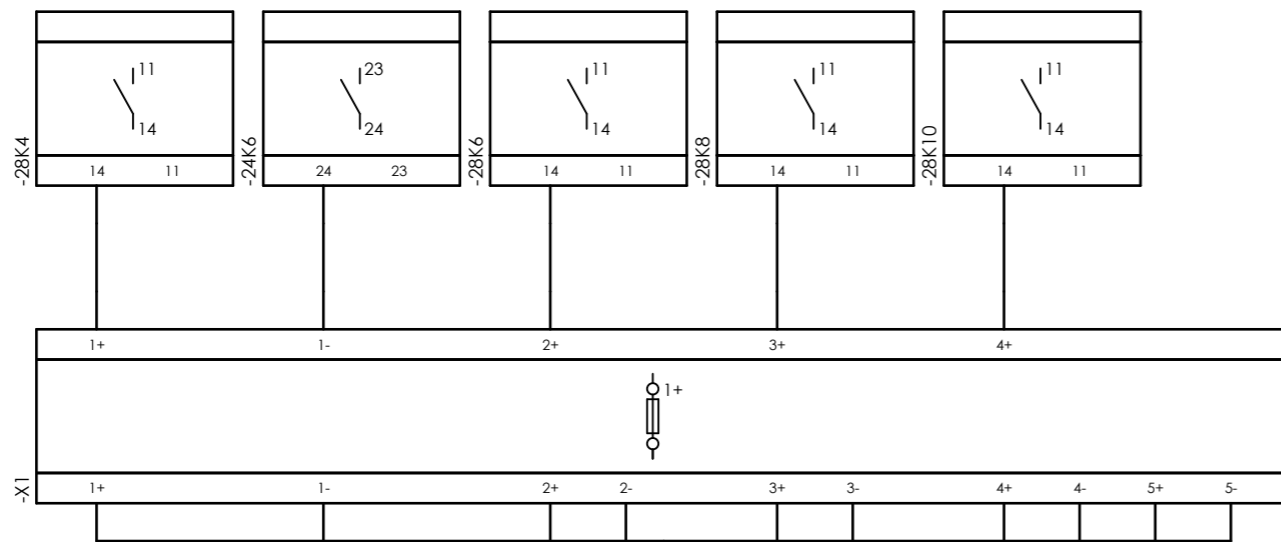

External targets

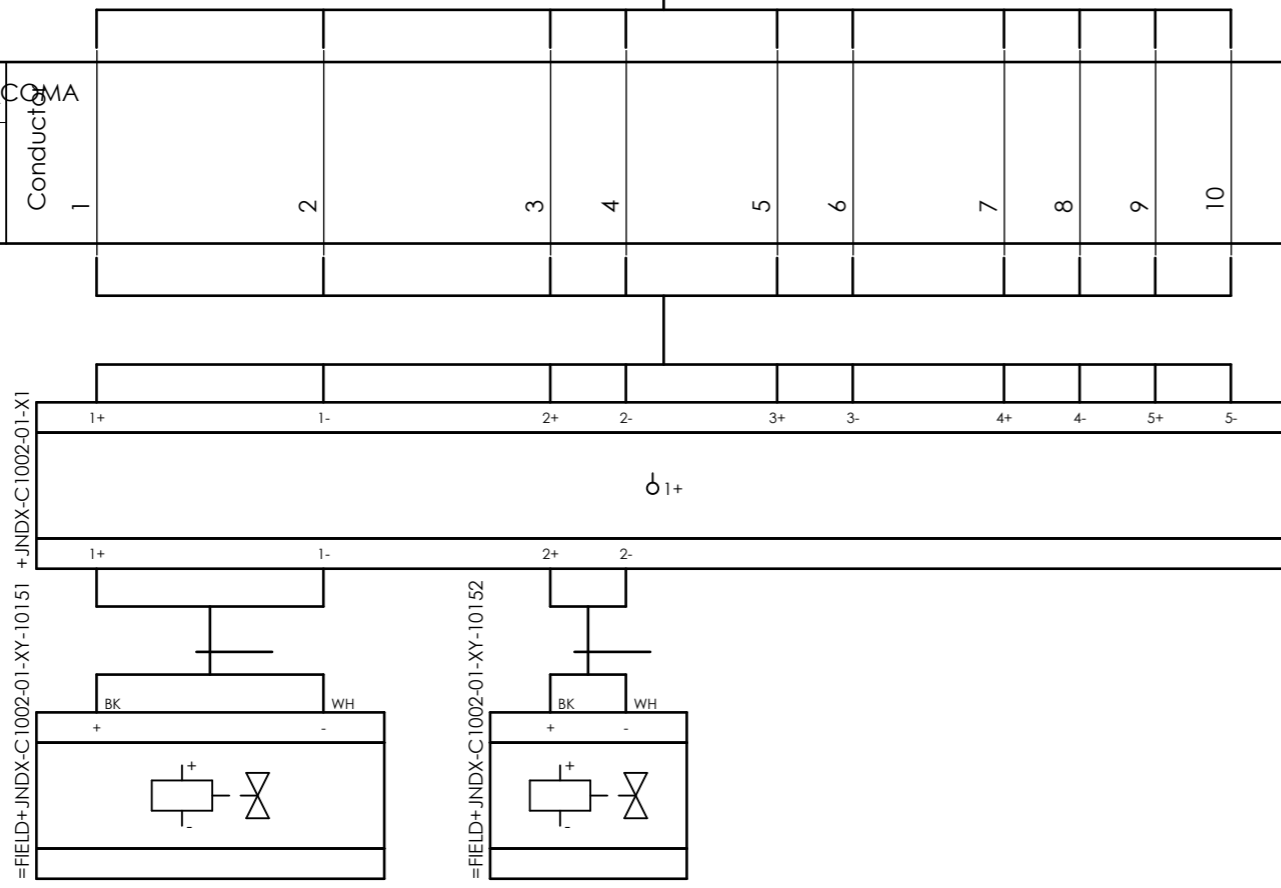


CLIENT DWG NO.	BU-20-VD-303-IN-DIG-0043
EQUIPMENT NO.	20-C-1002
EQUIPMENT LOCATION	Iran, Onshore
THIS DRAWING IS OWNED BY AIRPACK, AND SHALL NOT BE PRINTED OR COPIED IN ANY OTHER WAY THAN WITH AIRPACKS PERMISSION!	

SUBJECT Cable-connection diagram =20-C-1002+UCP-C1002-01-SOL_COMA	
ADAPTED TO P&ID REVISION	05
CLIENT	Bushehr Petrochemical Company (BUPC)
CLIENT REF.	Bushehr MEG Plant Project
AIRPACK REF.	17811-30A


DRAWN BY	MaGo
CHECKED BY	RBE
LAST MODIFICATION DATE	
AIRPACK DWG NO.	17811-05
REVISION	01
TOTAL PAGE AMOUNT	13

=	
+	
CURRENT PAGE	


Internal targets

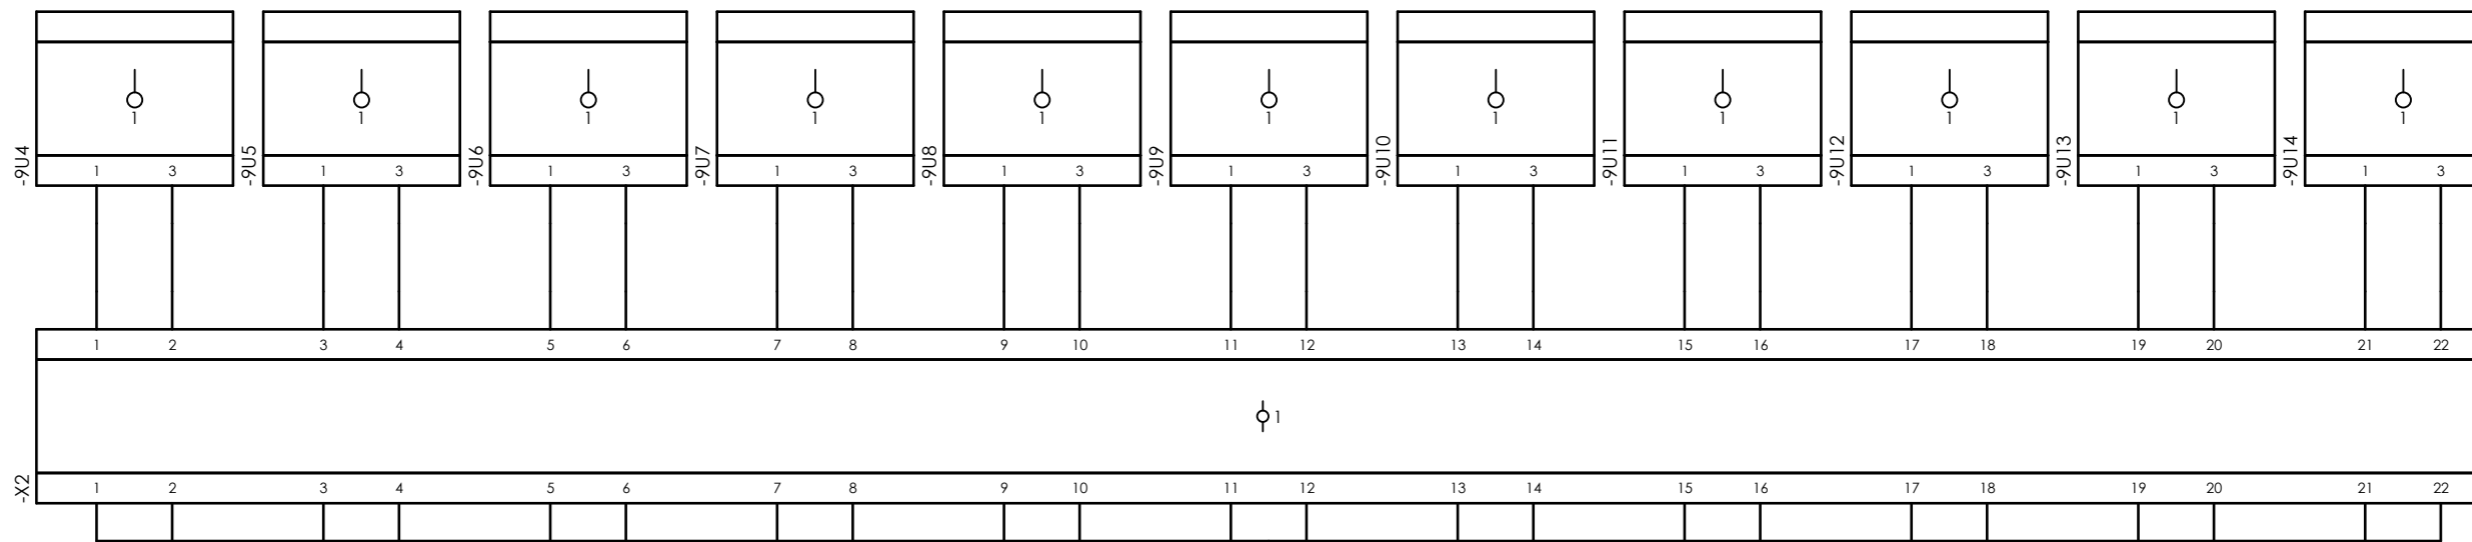

=20-C-1002+UCP-C1002-01-TR_COMA

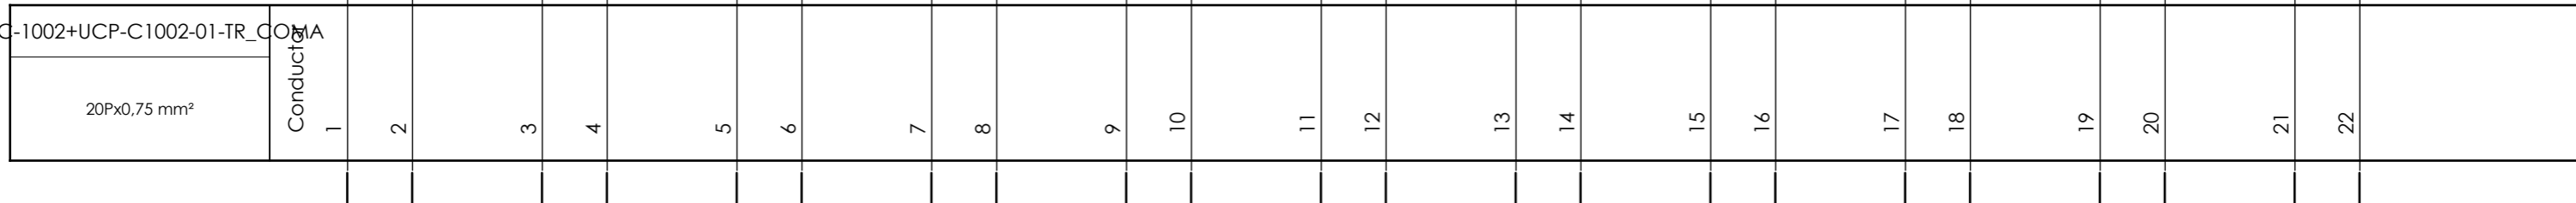

External targets

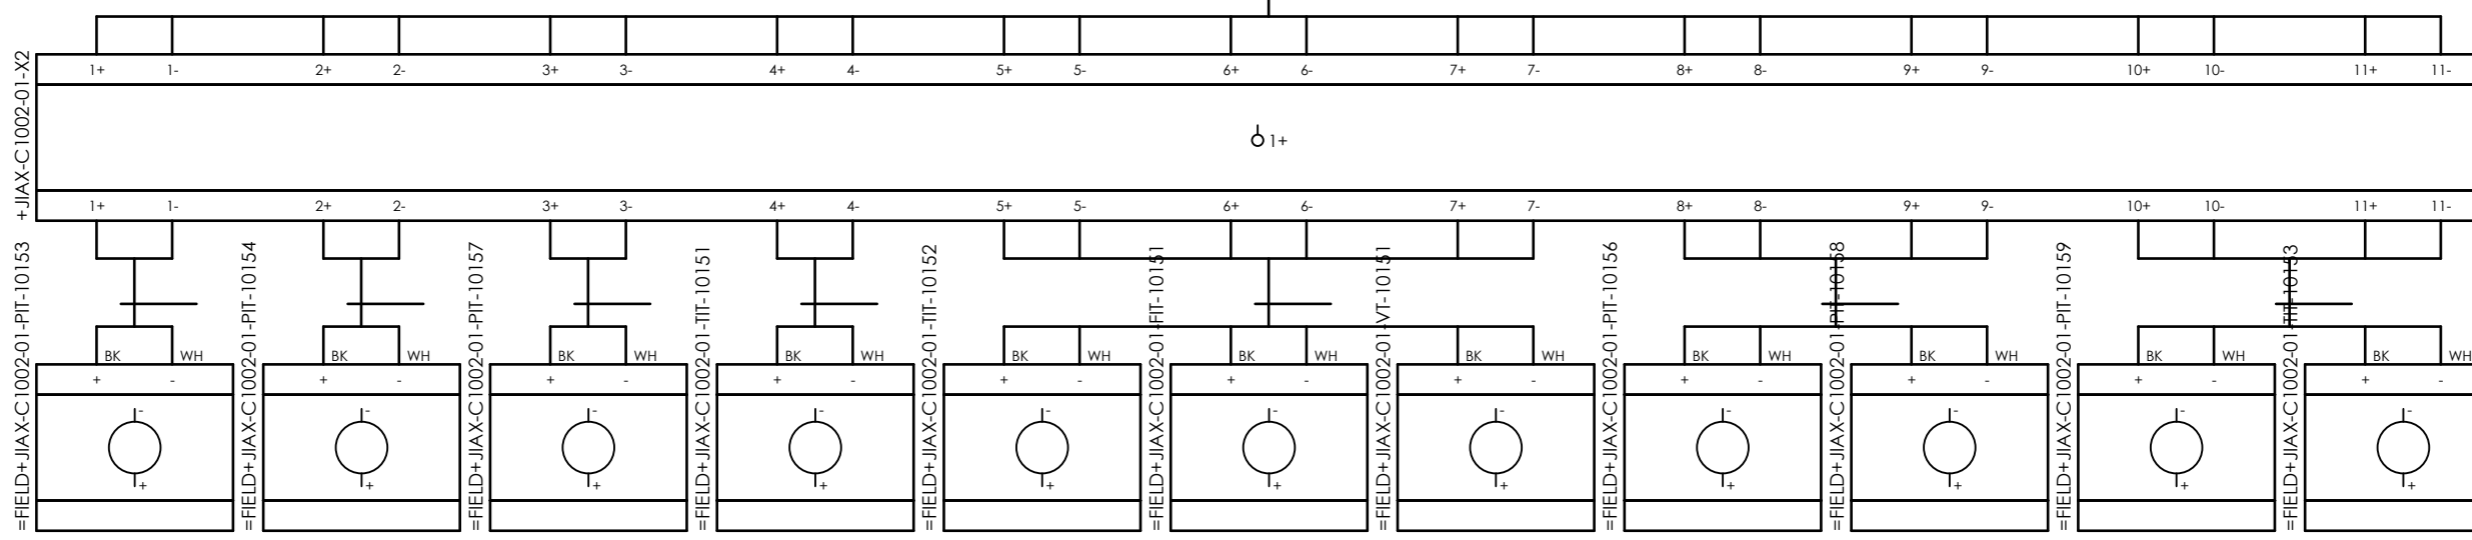


CLIENT DWG NO.	BU-20-VD-303-IN-DIG-0043
EQUIPMENT NO.	20-C-1002
EQUIPMENT LOCATION	Iran, Onshore
THIS DRAWING IS OWNED BY AIRPACK, AND SHALL NOT BE PRINTED OR COPIED IN ANY OTHER WAY THAN WITH AIRPACKS PERMISSION!	

SUBJECT		Cable-connection diagram =20-C-1002+UCP-C1002-01-TR_COMA	
ADAPTED TO P&ID REVISION	05		
CLIENT	Bushehr Petrochemical Company (BUPC)		
CLIENT REF.	Bushehr MEG Plant Project		
AIRPACK REF.	17811-30A		


DRAWN BY	MaGo
CHECKED BY	RBE
LAST MODIFICATION DATE	
AIRPACK DWG NO.	17811-05
REVISION	01
TOTAL PAGE AMOUNT	14

=	
+	
CURRENT PAGE	


Internal targets

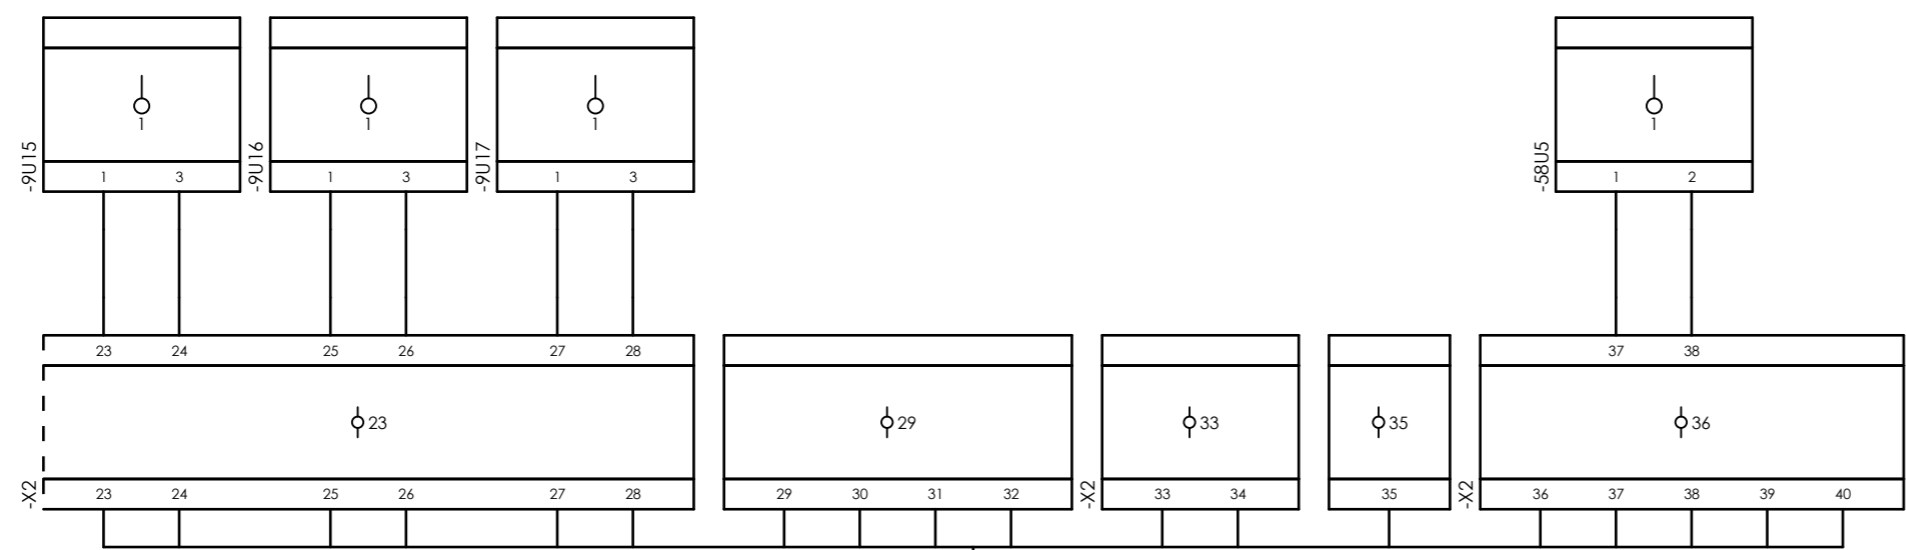

=20-C-1002+UCP-C1002-01-TR_COMA

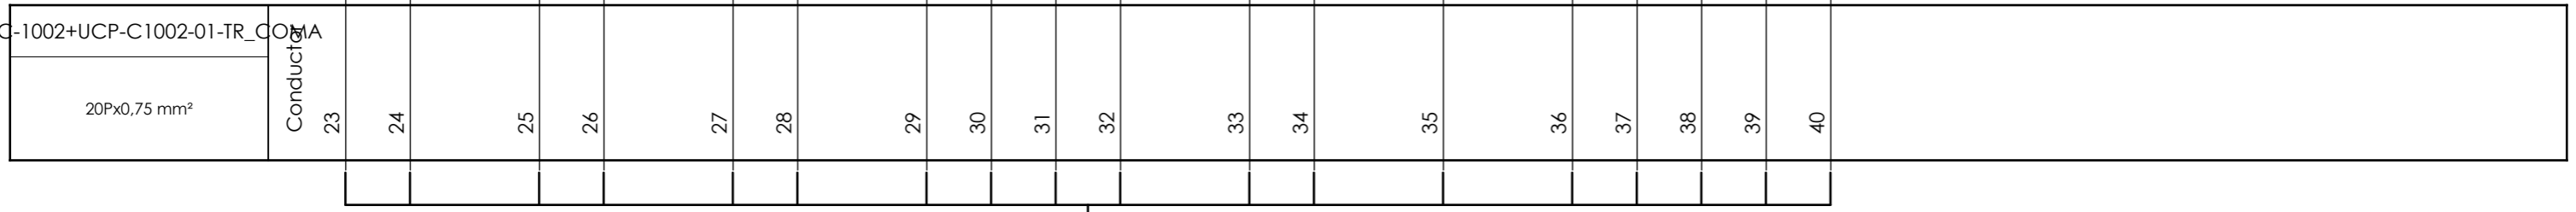

External targets

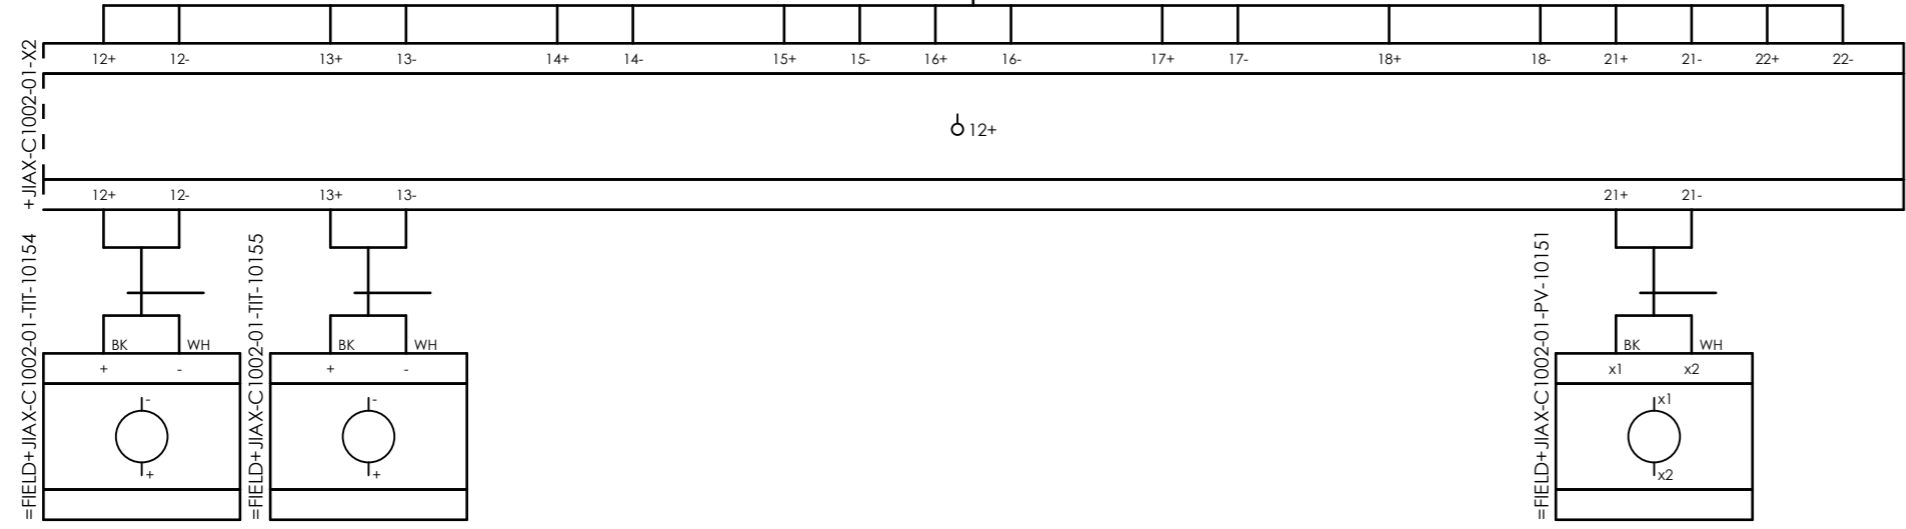


THIS DRAWING IS OWNED BY AIRPACK, AND SHALL NOT BE PRINTED OR COPIED IN ANY OTHER WAY THAN WITH AIRPACKS PERMISSION!


CLIENT DWG NO.	BU-20-VD-303-IN-DIG-0043	SUBJECT	Cable-connection diagram =20-C-1002+UCP-C1002-01-TR_COMA
EQUIPMENT NO.	20-C-1002	ADAPTED TO P&ID REVISION	05
EQUIPMENT LOCATION	Iran, Onshore	CLIENT	Bushehr Petrochemical Company (BUPC)
		CLIENT REF.	Bushehr MEG Plant Project
		AIRPACK REF.	17811-30A

DRAWN BY	MaGo	=
CHECKED BY	RBE	+
LAST MODIFICATION DATE		CURRENT PAGE
AIRPACK DWG NO.	17811-05	
REVISION	01	
TOTAL PAGE AMOUNT	15	


Internal targets

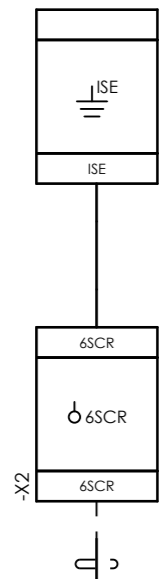


-X2

 

=20-C-1002+JIAX-C1002-01-FIT-10151

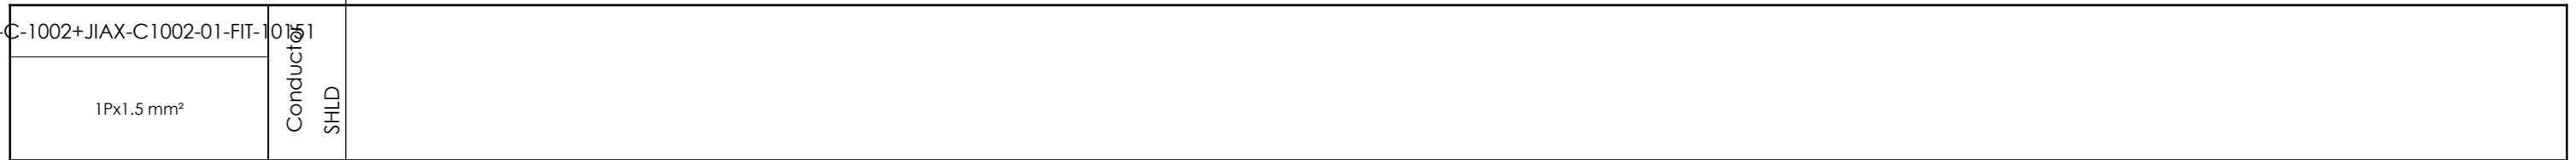

-FIT-10001

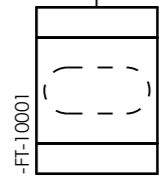

External targets




CLIENT DWG NO.	BU-20-VD-303-IN-DIG-0043
EQUIPMENT NO.	20-C-1002
EQUIPMENT LOCATION	Iran, Onshore
THIS DRAWING IS OWNED BY AIRPACK, AND SHALL NOT BE PRINTED OR COPIED IN ANY OTHER WAY THAN WITH AIRPACKS PERMISSION!	

SUBJECT Cable-connection diagram =20-C-1002+JIAX-C1002-01-FIT-10151	
ADAPTED TO P&ID REVISION	05
CLIENT	Bushehr Petrochemical Company (BUPC)
CLIENT REF.	Bushehr MEG Plant Project
AIRPACK REF.	17811-30A



DRAWN BY	MaGo
CHECKED BY	RBE
LAST MODIFICATION DATE	
AIRPACK DWG NO.	17811-05
REVISION	01
TOTAL PAGE AMOUNT	16

=
+
CURRENT PAGE

Internal targets

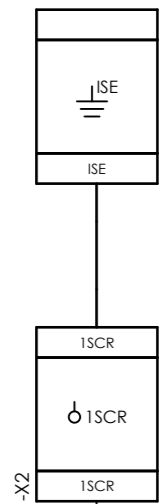

-X2

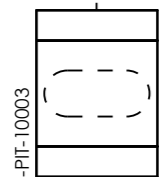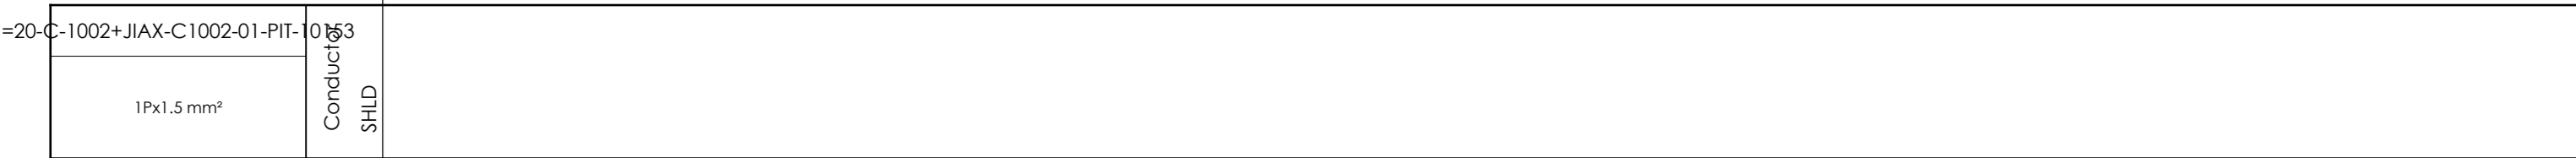

External targets





CLIENT DWG NO.	BU-20-VD-303-IN-DIG-0043
EQUIPMENT NO.	20-C-1002
EQUIPMENT LOCATION	Iran, Onshore
THIS DRAWING IS OWNED BY AIRPACK, AND SHALL NOT BE PRINTED OR COPIED IN ANY OTHER WAY THAN WITH AIRPACKS PERMISSION!	

SUBJECT		Cable-connection diagram =20-C-1002+JIAX-C1002-01-PIT-10153	
ADAPTED TO P&ID REVISION	05	CLIENT	Bushehr Petrochemical Company (BUPC)
AIRPACK REF.	17811-30A	CLIENT REF.	Bushehr MEG Plant Project



DRAWN BY	MaGo
CHECKED BY	RBE
LAST MODIFICATION DATE	
AIRPACK DWG NO.	17811-05
REVISION	01
TOTAL PAGE AMOUNT	17

=
+
CURRENT PAGE

 Internal targets

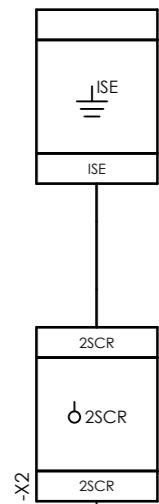

=20-C-1002+JIAX-C1002-01-PIT-10154

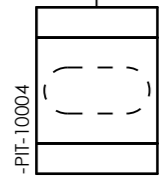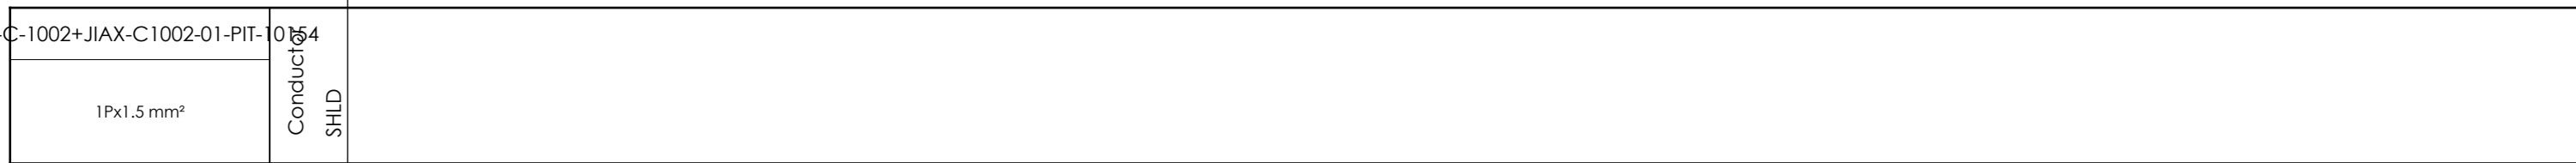

External targets





CLIENT DWG NO.	BU-20-VD-303-IN-DIG-0043
EQUIPMENT NO.	20-C-1002
EQUIPMENT LOCATION	Iran, Onshore
THIS DRAWING IS OWNED BY AIRPACK, AND SHALL NOT BE PRINTED OR COPIED IN ANY OTHER WAY THAN WITH AIRPACKS PERMISSION!	

SUBJECT Cable-connection diagram =20-C-1002+JIAX-C1002-01-PIT-10154	
ADAPTED TO P&ID REVISION	05
CLIENT	Bushehr Petrochemical Company (BUPC)
CLIENT REF.	Bushehr MEG Plant Project
AIRPACK REF.	17811-30A


DRAWN BY	MaGo
CHECKED BY	RBE
LAST MODIFICATION DATE	
AIRPACK DWG NO.	17811-05
REVISION	01
TOTAL PAGE AMOUNT	18

=
+
CURRENT PAGE

Internal targets

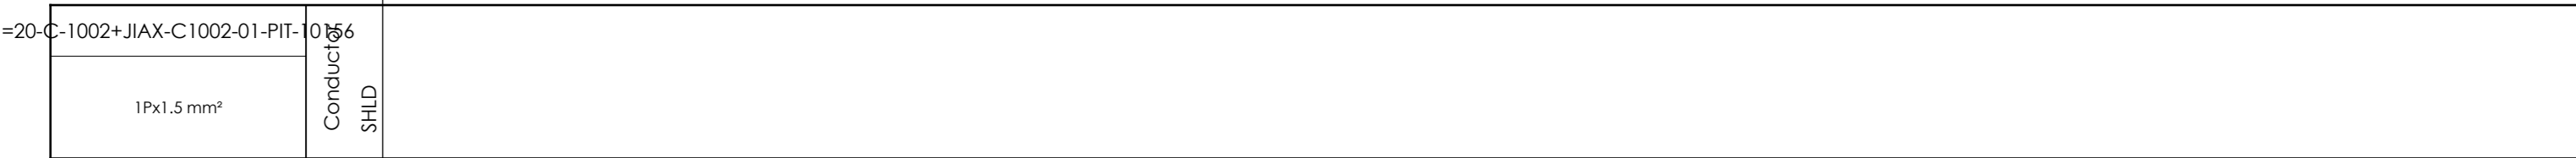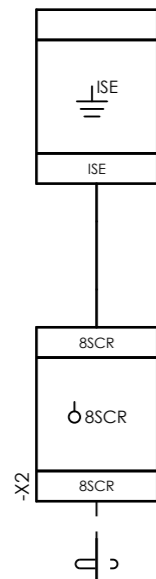

External targets

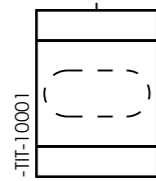



CLIENT DWG NO.	BU-20-VD-303-IN-DIG-0043
EQUIPMENT NO.	20-C-1002
EQUIPMENT LOCATION	Iran, Onshore
THIS DRAWING IS OWNED BY AIRPACK, AND SHALL NOT BE PRINTED OR COPIED IN ANY OTHER WAY THAN WITH AIRPACKS PERMISSION!	

SUBJECT Cable-connection diagram =20-C-1002+JIAX-C1002-01-PIT-10156	
ADAPTED TO P&ID REVISION	05
CLIENT	Bushehr Petrochemical Company (BUPC)
CLIENT REF.	Bushehr MEG Plant Project
AIRPACK REF.	17811-30A


DRAWN BY	MaGo
CHECKED BY	RBE
LAST MODIFICATION DATE	
AIRPACK DWG NO.	17811-05
REVISION	01
TOTAL PAGE AMOUNT	19

=
+
CURRENT PAGE

Internal targets

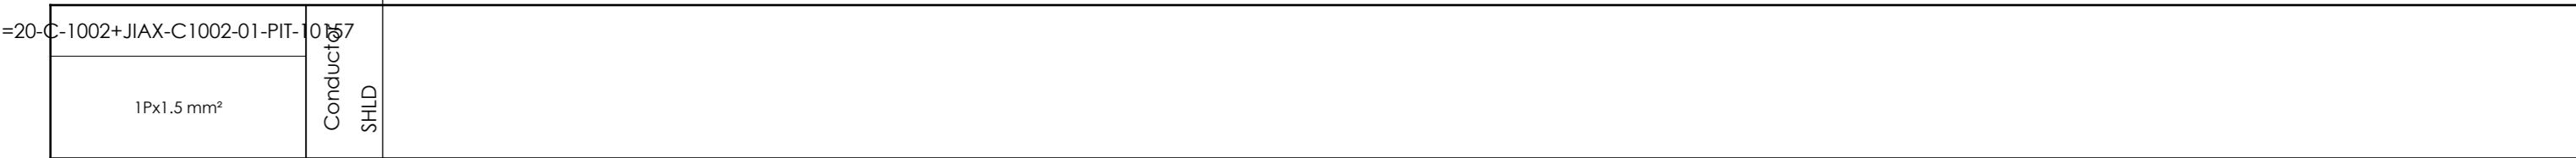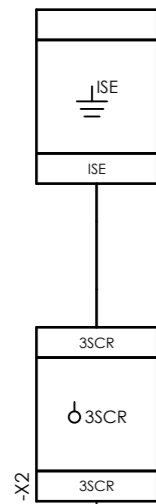

External targets

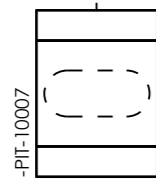



CLIENT DWG NO.	BU-20-VD-303-IN-DIG-0043
EQUIPMENT NO.	20-C-1002
EQUIPMENT LOCATION	Iran, Onshore
THIS DRAWING IS OWNED BY AIRPACK, AND SHALL NOT BE PRINTED OR COPIED IN ANY OTHER WAY THAN WITH AIRPACKS PERMISSION!	

SUBJECT		Cable-connection diagram =20-C-1002+JIAX-C1002-01-PIT-10157	
ADAPTED TO P&ID REVISION	05	CLIENT	Bushehr Petrochemical Company (BUPC)
CLIENT REF.	Bushehr MEG Plant Project	AIRPACK REF.	17811-30A



DRAWN BY	MaGo
CHECKED BY	RBE
LAST MODIFICATION DATE	
AIRPACK DWG NO.	17811-05
REVISION	01
TOTAL PAGE AMOUNT	20

=	
+	
CURRENT PAGE	

 Internal targets

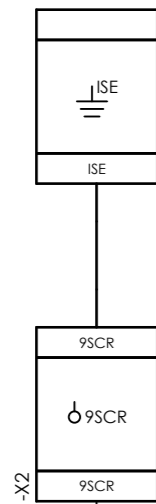

=20-C-1002+JIAX-C1002-01-PIT-10158

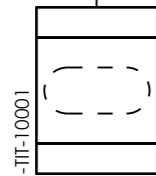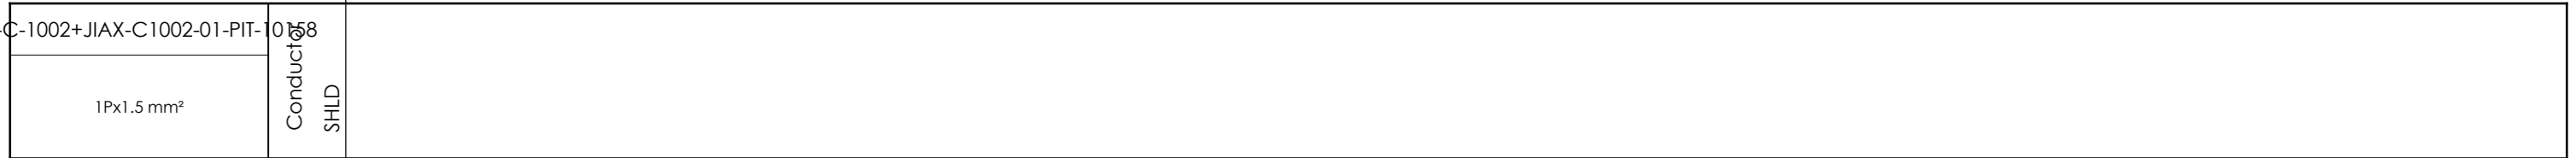

External targets




CLIENT DWG NO.	BU-20-VD-303-IN-DIG-0043
EQUIPMENT NO.	20-C-1002
EQUIPMENT LOCATION	Iran, Onshore
THIS DRAWING IS OWNED BY AIRPACK, AND SHALL NOT BE PRINTED OR COPIED IN ANY OTHER WAY THAN WITH AIRPACKS PERMISSION!	

SUBJECT		Cable-connection diagram =20-C-1002+JIAX-C1002-01-PIT-10158	
ADAPTED TO P&ID REVISION	05	CLIENT	Bushehr Petrochemical Company (BUPC)
CLIENT REF.	Bushehr MEG Plant Project	AIRPACK REF.	17811-30A

DRAWN BY	MaGo
CHECKED BY	RBE
LAST MODIFICATION DATE	
AIRPACK DWG NO.	17811-05
REVISION	01
TOTAL PAGE AMOUNT	21


=	
+	
CURRENT PAGE	

Internal targets

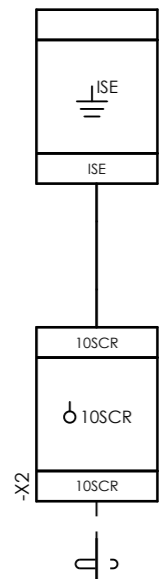


-X2

=20-C-1002+JIAX-C1002-01-PIT-10159

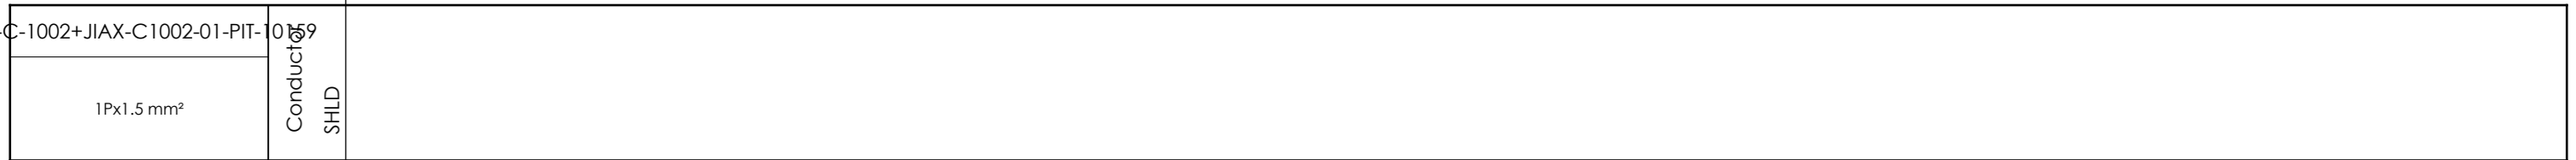

External targets

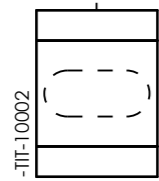



CLIENT DWG NO.	BU-20-VD-303-IN-DIG-0043
EQUIPMENT NO.	20-C-1002
EQUIPMENT LOCATION	Iran, Onshore
THIS DRAWING IS OWNED BY AIRPACK, AND SHALL NOT BE PRINTED OR COPIED IN ANY OTHER WAY THAN WITH AIRPACKS PERMISSION!	

SUBJECT		Cable-connection diagram =20-C-1002+JIAX-C1002-01-PIT-10159	
ADAPTED TO P&ID REVISION	05	CLIENT	Bushehr Petrochemical Company (BUPC)
CLIENT REF.	Bushehr MEG Plant Project	AIRPACK REF.	17811-30A


DRAWN BY	MaGo
CHECKED BY	RBE
LAST MODIFICATION DATE	
AIRPACK DWG NO.	17811-05
REVISION	01
TOTAL PAGE AMOUNT	22

=
+
CURRENT PAGE

Internal targets

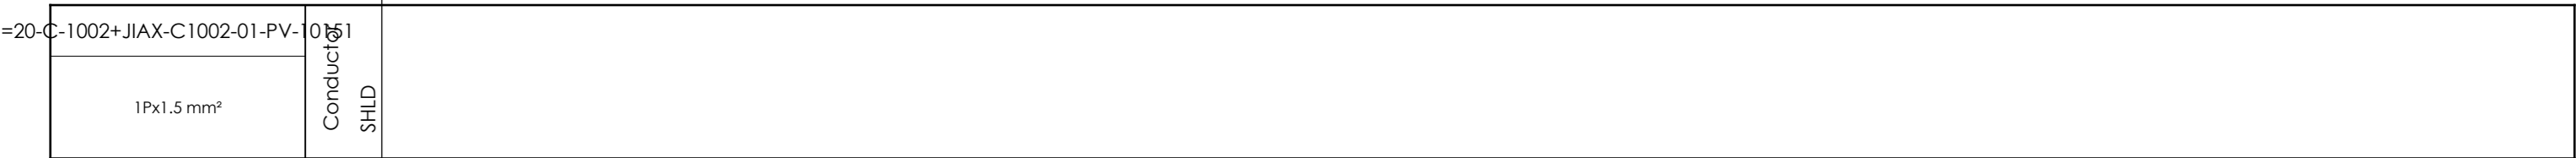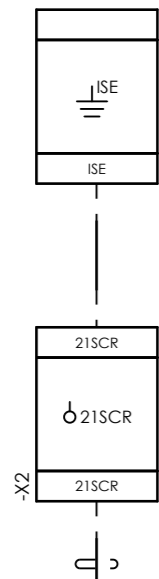

External targets

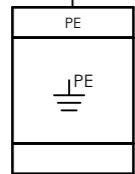


CLIENT DWG NO.	BU-20-VD-303-IN-DIG-0043
EQUIPMENT NO.	20-C-1002
EQUIPMENT LOCATION	Iran, Onshore
THIS DRAWING IS OWNED BY AIRPACK, AND SHALL NOT BE PRINTED OR COPIED IN ANY OTHER WAY THAN WITH AIRPACKS PERMISSION!	


SUBJECT		Cable-connection diagram =20-C-1002+JIAX-C1002-01-PV-10151	
ADAPTED TO P&ID REVISION	05	CLIENT	Bushehr Petrochemical Company (BUPC)
CLIENT REF.	Bushehr MEG Plant Project	AIRPACK REF.	17811-30A

DRAWN BY	MaGo	=
CHECKED BY	RBE	+
LAST MODIFICATION DATE		CURRENT PAGE
AIRPACK DWG NO.	17811-05	
REVISION	01	
TOTAL PAGE AMOUNT	23	

Internal targets

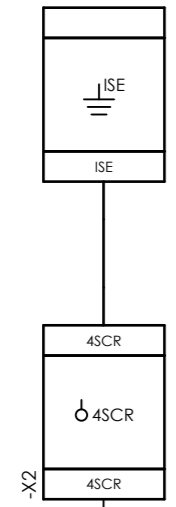

External targets

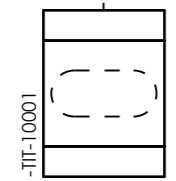

CLIENT DWG NO.	BU-20-VD-303-IN-DIG-0043
EQUIPMENT NO.	20-C-1002
EQUIPMENT LOCATION	Iran, Onshore

SUBJECT	
Cable-connection diagram =20-C-1002+JIAX-C1002-01-TIT-10151	
ADAPTED TO P&ID REVISION	05

DRAWN BY	MaGo	=
CHECKED BY	RBE	+
LAST MODIFICATION DATE		


THIS DRAWING IS OWNED BY AIRPACK, AND SHALL NOT BE PRINTED OR COPIED IN ANY OTHER WAY THAN WITH AIRPACKS PERMISSION!

CLIENT	Bushehr Petrochemical Company (BUPC)
CLIENT REF.	Bushehr MEG Plant Project
AIRPACK REF.	17811-30A

AIRPACK DWG NO.	17811-05
REVISION	01
TOTAL PAGE AMOUNT	24


CURRENT PAGE

Internal targets

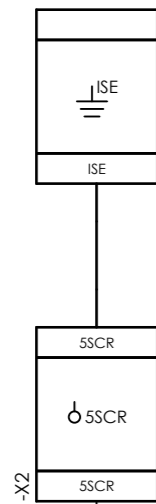


-X2

=20-C-1002+JIAX-C1002-01-TIT-10152

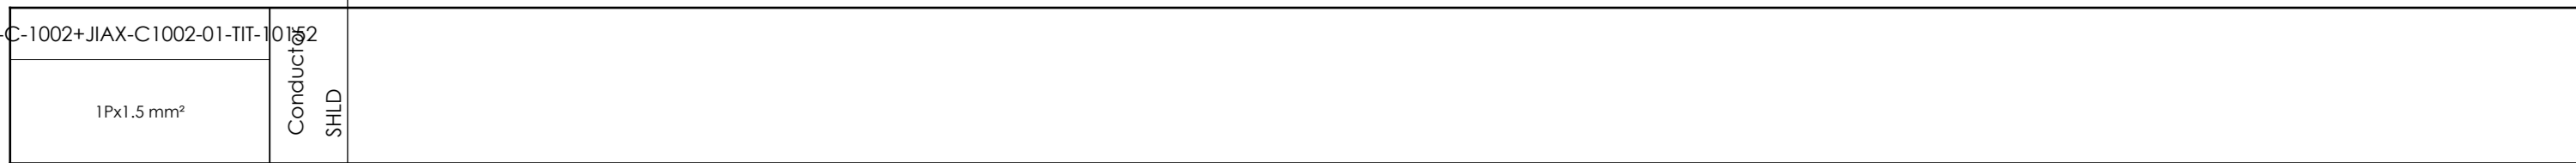

-X2

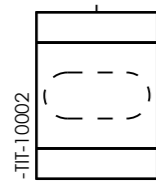

External targets



CLIENT DWG NO.	BU-20-VD-303-IN-DIG-0043
EQUIPMENT NO.	20-C-1002
EQUIPMENT LOCATION	Iran, Onshore

SUBJECT	
Cable-connection diagram =20-C-1002+JIAX-C1002-01-TIT-10152	
ADAPTED TO P&ID REVISION	05

DRAWN BY	MaGo
CHECKED BY	RBE
LAST MODIFICATION DATE	


THIS DRAWING IS OWNED BY AIRPACK, AND SHALL NOT BE PRINTED OR COPIED IN ANY OTHER WAY THAN WITH AIRPACKS PERMISSION!

CLIENT	Bushehr Petrochemical Company (BUPC)
CLIENT REF.	Bushehr MEG Plant Project
AIRPACK REF.	17811-30A



AIRPACK DWG NO.	17811-05
REVISION	01
TOTAL PAGE AMOUNT	25

=
+
CURRENT PAGE

Internal targets

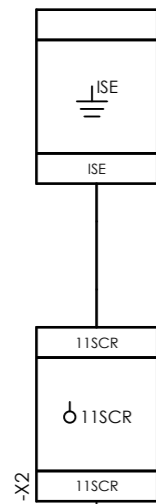

-X2

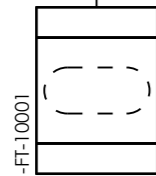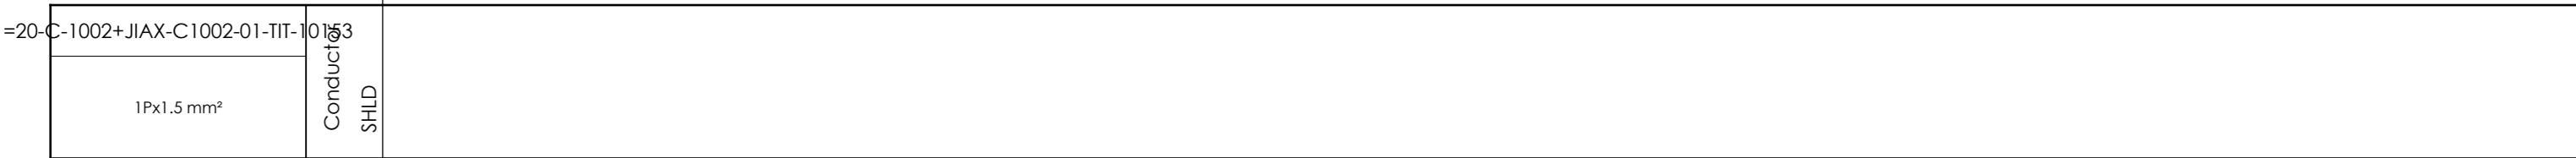

External targets



CLIENT DWG NO.	BU-20-VD-303-IN-DIG-0043
EQUIPMENT NO.	20-C-1002
EQUIPMENT LOCATION	Iran, Onshore



THIS DRAWING IS OWNED BY AIRPACK, AND SHALL NOT BE PRINTED OR COPIED IN ANY OTHER WAY THAN WITH AIRPACKS PERMISSION!

SUBJECT		Cable-connection diagram =20-C-1002+JIAX-C1002-01-TIT-10153	
ADAPTED TO P&ID REVISION	05	CLIENT	Bushehr Petrochemical Company (BUPC)
CLIENT REF.	Bushehr MEG Plant Project	AIRPACK REF.	17811-30A



DRAWN BY	MaGo
CHECKED BY	RBE
LAST MODIFICATION DATE	
AIRPACK DWG NO.	17811-05
REVISION	01
TOTAL PAGE AMOUNT	26

=	
+	
CURRENT PAGE	

 Internal targets

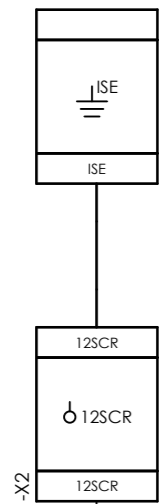

=20-C-1002+JIAX-C1002-01-TIT-10154

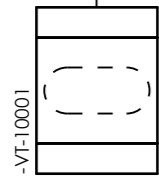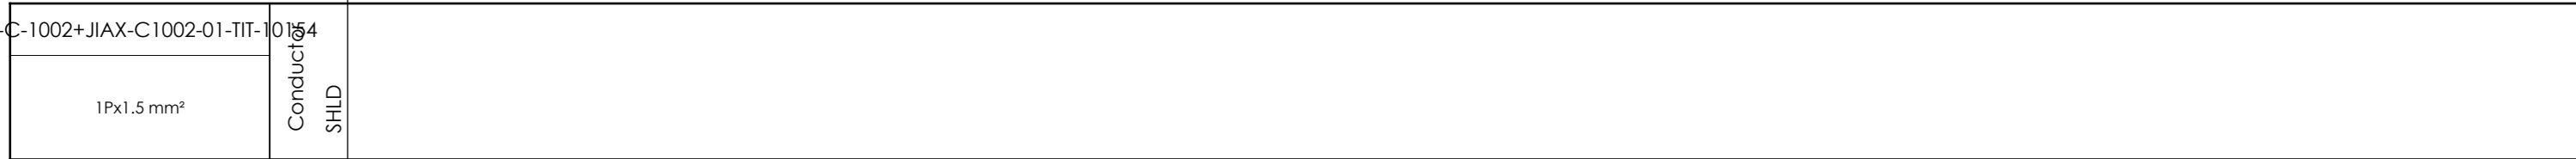

External targets





CLIENT DWG NO.	BU-20-VD-303-IN-DIG-0043
EQUIPMENT NO.	20-C-1002
EQUIPMENT LOCATION	Iran, Onshore
THIS DRAWING IS OWNED BY AIRPACK, AND SHALL NOT BE PRINTED OR COPIED IN ANY OTHER WAY THAN WITH AIRPACKS PERMISSION!	

SUBJECT		Cable-connection diagram =20-C-1002+JIAX-C1002-01-TIT-10154	
ADAPTED TO P&ID REVISION	05	CLIENT	Bushehr Petrochemical Company (BUPC)
CLIENT REF.	Bushehr MEG Plant Project	AIRPACK REF.	17811-30A




DRAWN BY	MaGo
CHECKED BY	RBE
LAST MODIFICATION DATE	
AIRPACK DWG NO.	17811-05
REVISION	01
TOTAL PAGE AMOUNT	27

=	
+	
CURRENT PAGE	

 Internal targets

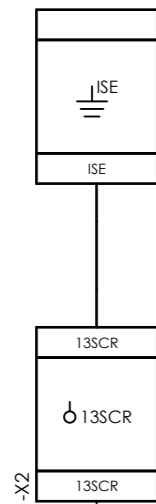

=20-C-1002+JIAX-C1002-01-TIT-10155

 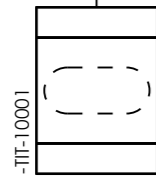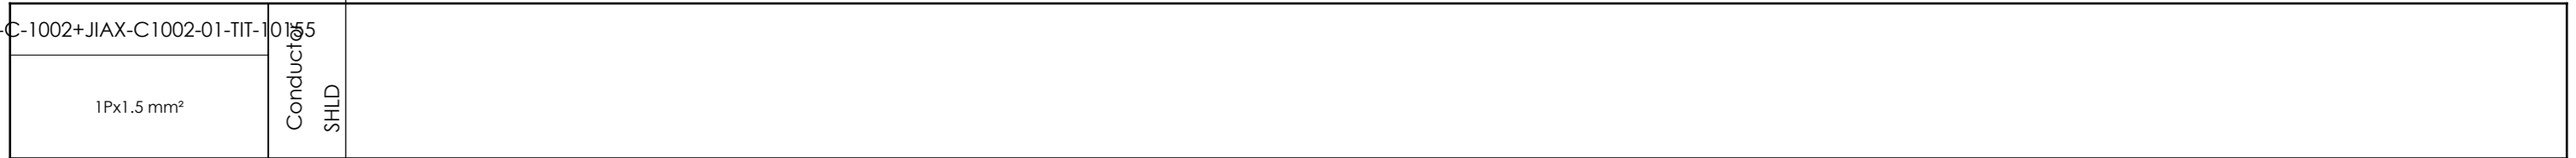

External targets



CLIENT DWG NO.	BU-20-VD-303-IN-DIG-0043
EQUIPMENT NO.	20-C-1002
EQUIPMENT LOCATION	Iran, Onshore

SUBJECT	
Cable-connection diagram =20-C-1002+JIAX-C1002-01-TIT-10155	
ADAPTED TO P&ID REVISION	05

DRAWN BY	MaGo	=
CHECKED BY	RBE	+
LAST MODIFICATION DATE		


THIS DRAWING IS OWNED BY AIRPACK, AND SHALL NOT BE PRINTED OR COPIED IN ANY OTHER WAY THAN WITH AIRPACKS PERMISSION!

CLIENT	Bushehr Petrochemical Company (BUPC)
CLIENT REF.	Bushehr MEG Plant Project
AIRPACK REF.	17811-30A

AIRPACK DWG NO.	17811-05
REVISION	01
TOTAL PAGE AMOUNT	28

CURRENT PAGE



Internal targets

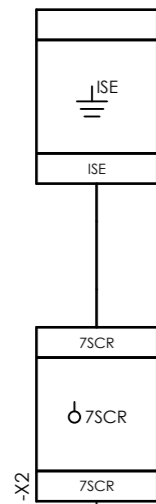

-X2



=20-C-1002+JIAX-C1002-01-VT-10151

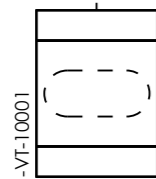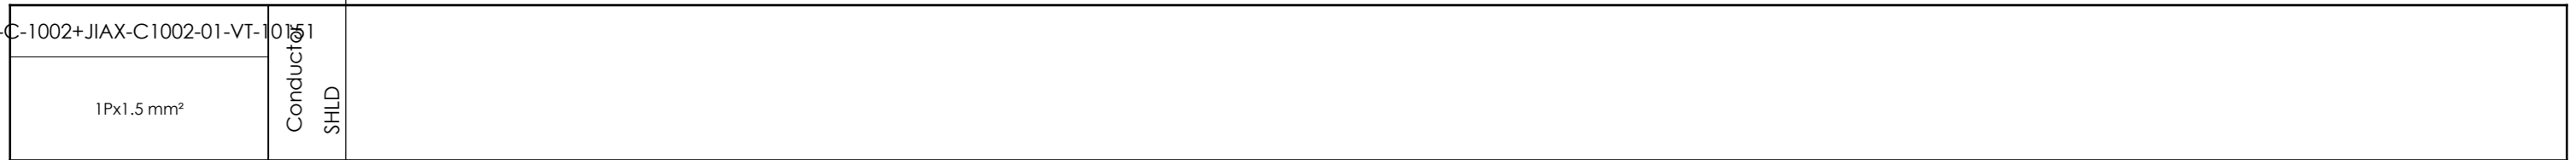

External targets



CLIENT DWG NO.	BU-20-VD-303-IN-DIG-0043
EQUIPMENT NO.	20-C-1002
EQUIPMENT LOCATION	Iran, Onshore

SUBJECT	
Cable-connection diagram =20-C-1002+JIAX-C1002-01-VT-10151	
ADAPTED TO P&ID REVISION	05

DRAWN BY	MaGo
CHECKED BY	RBE
LAST MODIFICATION DATE	


THIS DRAWING IS OWNED BY AIRPACK, AND SHALL NOT BE PRINTED OR COPIED IN ANY OTHER WAY THAN WITH AIRPACKS PERMISSION!

CLIENT	Bushehr Petrochemical Company (BUPC)
CLIENT REF.	Bushehr MEG Plant Project
AIRPACK REF.	17811-30A


AIRPACK DWG NO.	17811-05
REVISION	01
TOTAL PAGE AMOUNT	29

=
+
CURRENT PAGE

Internal targets

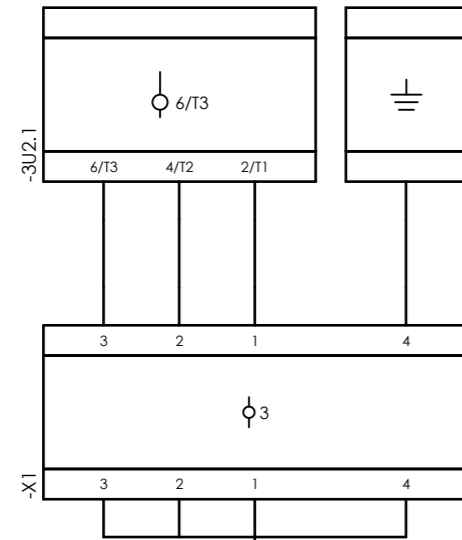


External targets

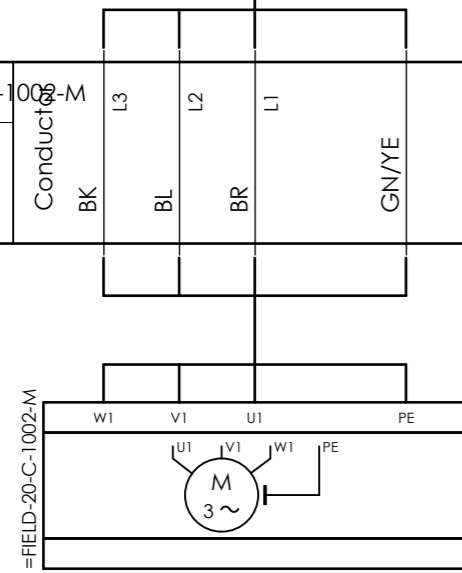


CLIENT DWG NO.	BU-20-VD-303-IN-DIG-0043
EQUIPMENT NO.	20-C-1002
EQUIPMENT LOCATION	Iran, Onshore
THIS DRAWING IS OWNED BY AIRPACK, AND SHALL NOT BE PRINTED OR COPIED IN ANY OTHER WAY THAN WITH AIRPACKS PERMISSION!	

SUBJECT		DRAWN BY	MaGo	=
Cable-connection diagram =20-C-1002+PD-C-1002-01-20-C-1002-M		CHECKED BY	RBE	+
ADAPTED TO P&ID REVISION	05	LAST MODIFICATION DATE		CURRENT PAGE
CLIENT	Bushehr Petrochemical Company (BUPC)	AIRPACK DWG NO.	17811-05	
CLIENT REF.	Bushehr MEG Plant Project	REVISION	01	
AIRPACK REF.	17811-30A	TOTAL PAGE AMOUNT	30	

Internal targets

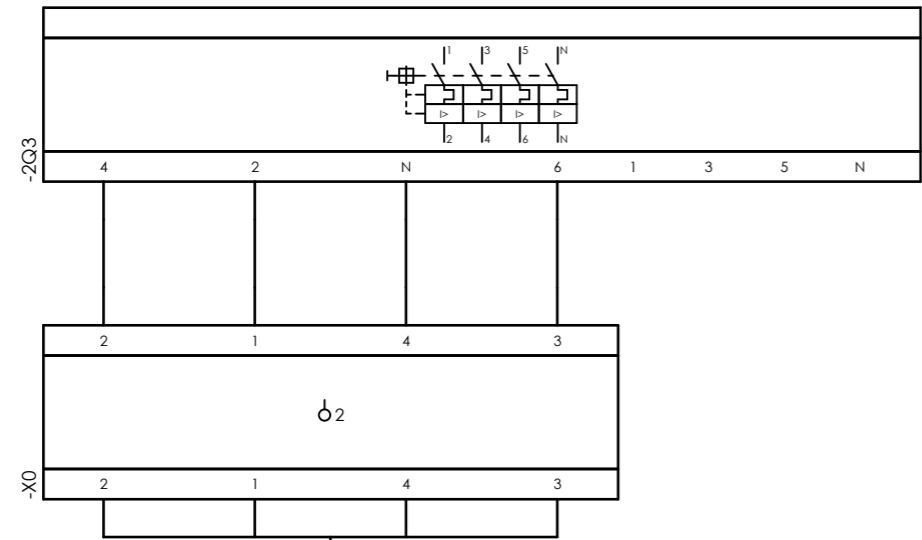

External targets

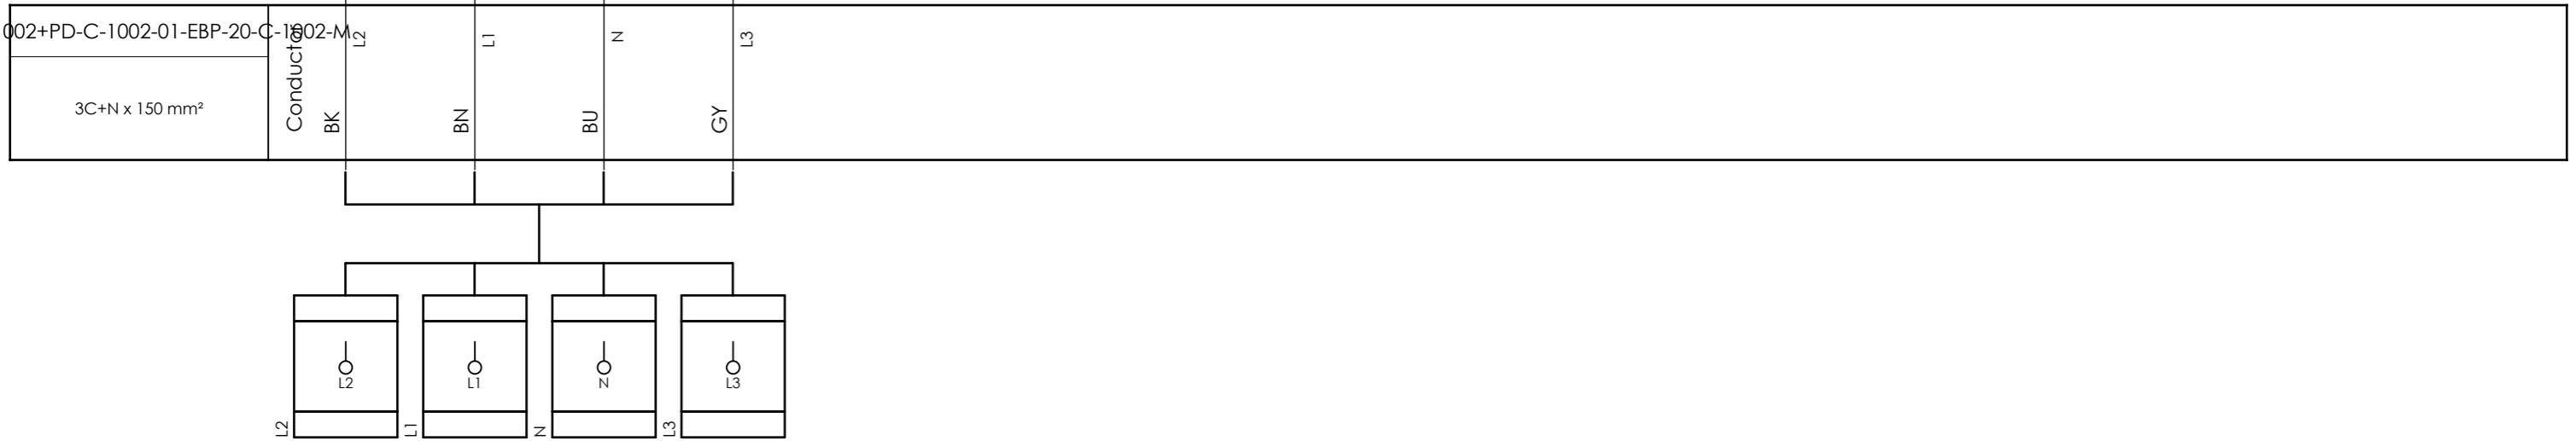


CLIENT DWG NO.	BU-20-VD-303-IN-DIG-0043
EQUIPMENT NO.	20-C-1002
EQUIPMENT LOCATION	Iran, Onshore
THIS DRAWING IS OWNED BY AIRPACK, AND SHALL NOT BE PRINTED OR COPIED IN ANY OTHER WAY THAN WITH AIRPACKS PERMISSION!	

SUBJECT		Cable-connection diagram =20-C-1002+PD-C-1002-01-EBP-20-C-1002-M
ADAPTED TO P&ID REVISION	05	
CLIENT	Bushehr Petrochemical Company (BUPC)	
CLIENT REF.	Bushehr MEG Plant Project	
AIRPACK REF.	17811-30A	


DRAWN BY	MaGo	=
CHECKED BY	RBE	+
LAST MODIFICATION DATE		
AIRPACK DWG NO.	17811-05	
REVISION	01	
TOTAL PAGE AMOUNT	31	

CURRENT PAGE	
--------------	--


Internal targets

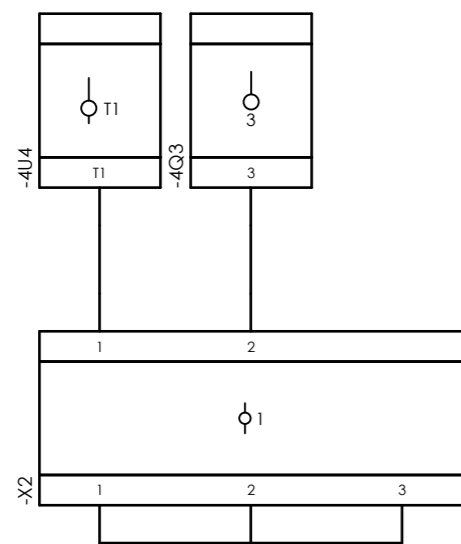

=20-C-1002+PD-C-1002-01-LG-10151

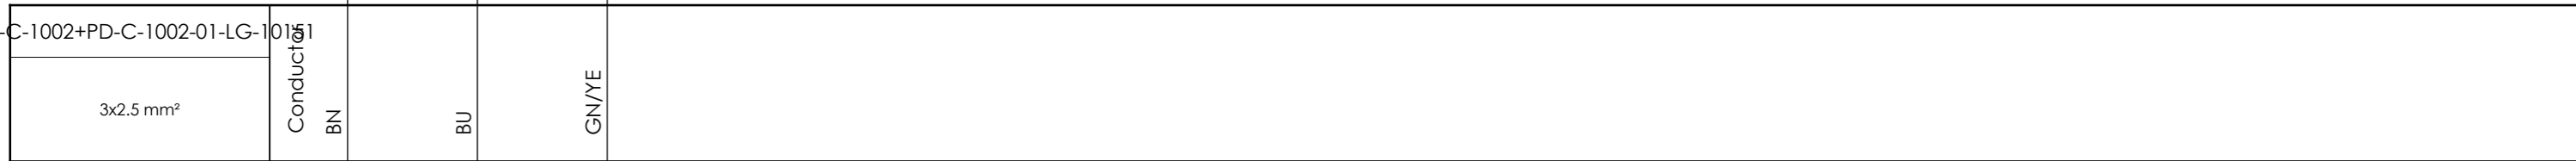

External targets

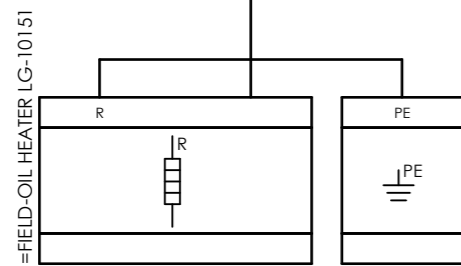

CLIENT DWG NO.	BU-20-VD-303-IN-DIG-0043
EQUIPMENT NO.	20-C-1002
EQUIPMENT LOCATION	Iran, Onshore
THIS DRAWING IS OWNED BY AIRPACK, AND SHALL NOT BE PRINTED OR COPIED IN ANY OTHER WAY THAN WITH AIRPACKS PERMISSION!	

SUBJECT		DRAWN BY	MaGo	=
Cable-connection diagram =20-C-1002+PD-C-1002-01-LG-10151		CHECKED BY	RBE	+
ADAPTED TO P&ID REVISION	05	LAST MODIFICATION DATE		CURRENT PAGE
CLIENT	Bushehr Petrochemical Company (BUPC)	AIRPACK DWG NO.	17811-05	
CLIENT REF.	Bushehr MEG Plant Project	REVISION	01	
AIRPACK REF.	17811-30A	TOTAL PAGE AMOUNT	32	

