



Vendor	ABT 360 KT/Y PP PLANT Project		Owner
	Piping & Instrument Diagram (P&ID)		 سراج گستران رجمال SERAJ GOSTARAN REJAL (سهامی خاص)
	Vendor's Doc. No.: 2 3 2 4 9 - 0 3	Rev.: 02	
	PPEC Doc. No.: L03-RE037-PR-PID-001		

PPEC REQ. NO. : L03-RE037-PR-PID-001

ITEM NO. :

TOTAL PAGES : 03

- **NO COMMENTS** : Documents/Drawings Were Checked By PPEC And Further Step Can Be Followed.
- **COMMENTED AS MARKED:** Documents/Drawings Were Checked By PPEC And Marked Comments Must Be Considered By Vendor. Vendor Shall Revise Documents/Drawing As Per Comments And The New Revision Of Documents/Drawings Must Be Revised Prior To Fabrication.
- **REJECTED:** Documents/Drawings Were Checked And It Is Not In Comply With Purchase Requisition Requirements.
- **ACCEPTABLE WITH COMMENTS:** Documents/Drawings Were Checked By PPEC And Comments Must Be Considered By Vendor. Fabrication Can Proceed Accordingly. Revised Document To Be Issued Either For Review Or As Final Certified. However PPEC Will Check The Revised Document For Proper Incorporation Of Comments.
- **NOT RETURNED:** Document Was Received For Information And Not Returned To The Vendor.



Name :
Signature:
Date :

Req. No. :


Seq. No.:


PPEC review & comments does not absolve the vendor of the responsibility for the corrected design, manufacturing and operation of the equipment

02	22-07-2025	Issue for Engineering	S.K.	S.K.	J.J.	
01	27-05-2025	Issue for Engineering	S.K.	S.K.	J.J.	
00	28-03-2025	Issue for Engineering	S.K.	S.K.	J.J.	
REV.	DATE	Description	Prepared by	Checked by	Approved by	Authorized by


<div>Vendor</div> <div></div>	<div>ABT 360 KT/Y PP PLANT</div>		<div>Contractor (DEC)</div>	<div>Owner</div> <div><div>سراج گستران رجال SERAJ GOSTARAN REJAL (بهامی خانجی)</div></div>
	<div>Piping & Instrument Diagram (P&ID)</div>			
	<div>Vendor's Doc. No.: 2 3 2 4 9 - 0 3</div> <div>PPEC Doc. No.: L03-RE037-PR-PID-001</div>	<div>Rev.: 02</div>		

PAGE NO.		CHANGE INDEX DURING FORMAL ISSUE						REASON OF LATEST CHANGE
		FIRST ISSUE	SECOND ISSUE	THIRTH ISSUE	FOURTH ISSUE	FIFTH ISSUE	SIXTH ISSUE	
		REV.00	REV.01	REV.02	REV.03	REV.04	REV.05	
1		X	X	X				
2		X	X	X				
3		X	X	X				
4		X	X	X				
5		X	X	X				
6								
7								
8								
9								
10								
11								
12								
13								
14								
15								
16								
17								
18								
19								
20								
21								
22								
23								
24								
25								
26								
27								
28								
29								
30								
31								
32								
33								
34								
35								
36								
37								
38								
39								
40								

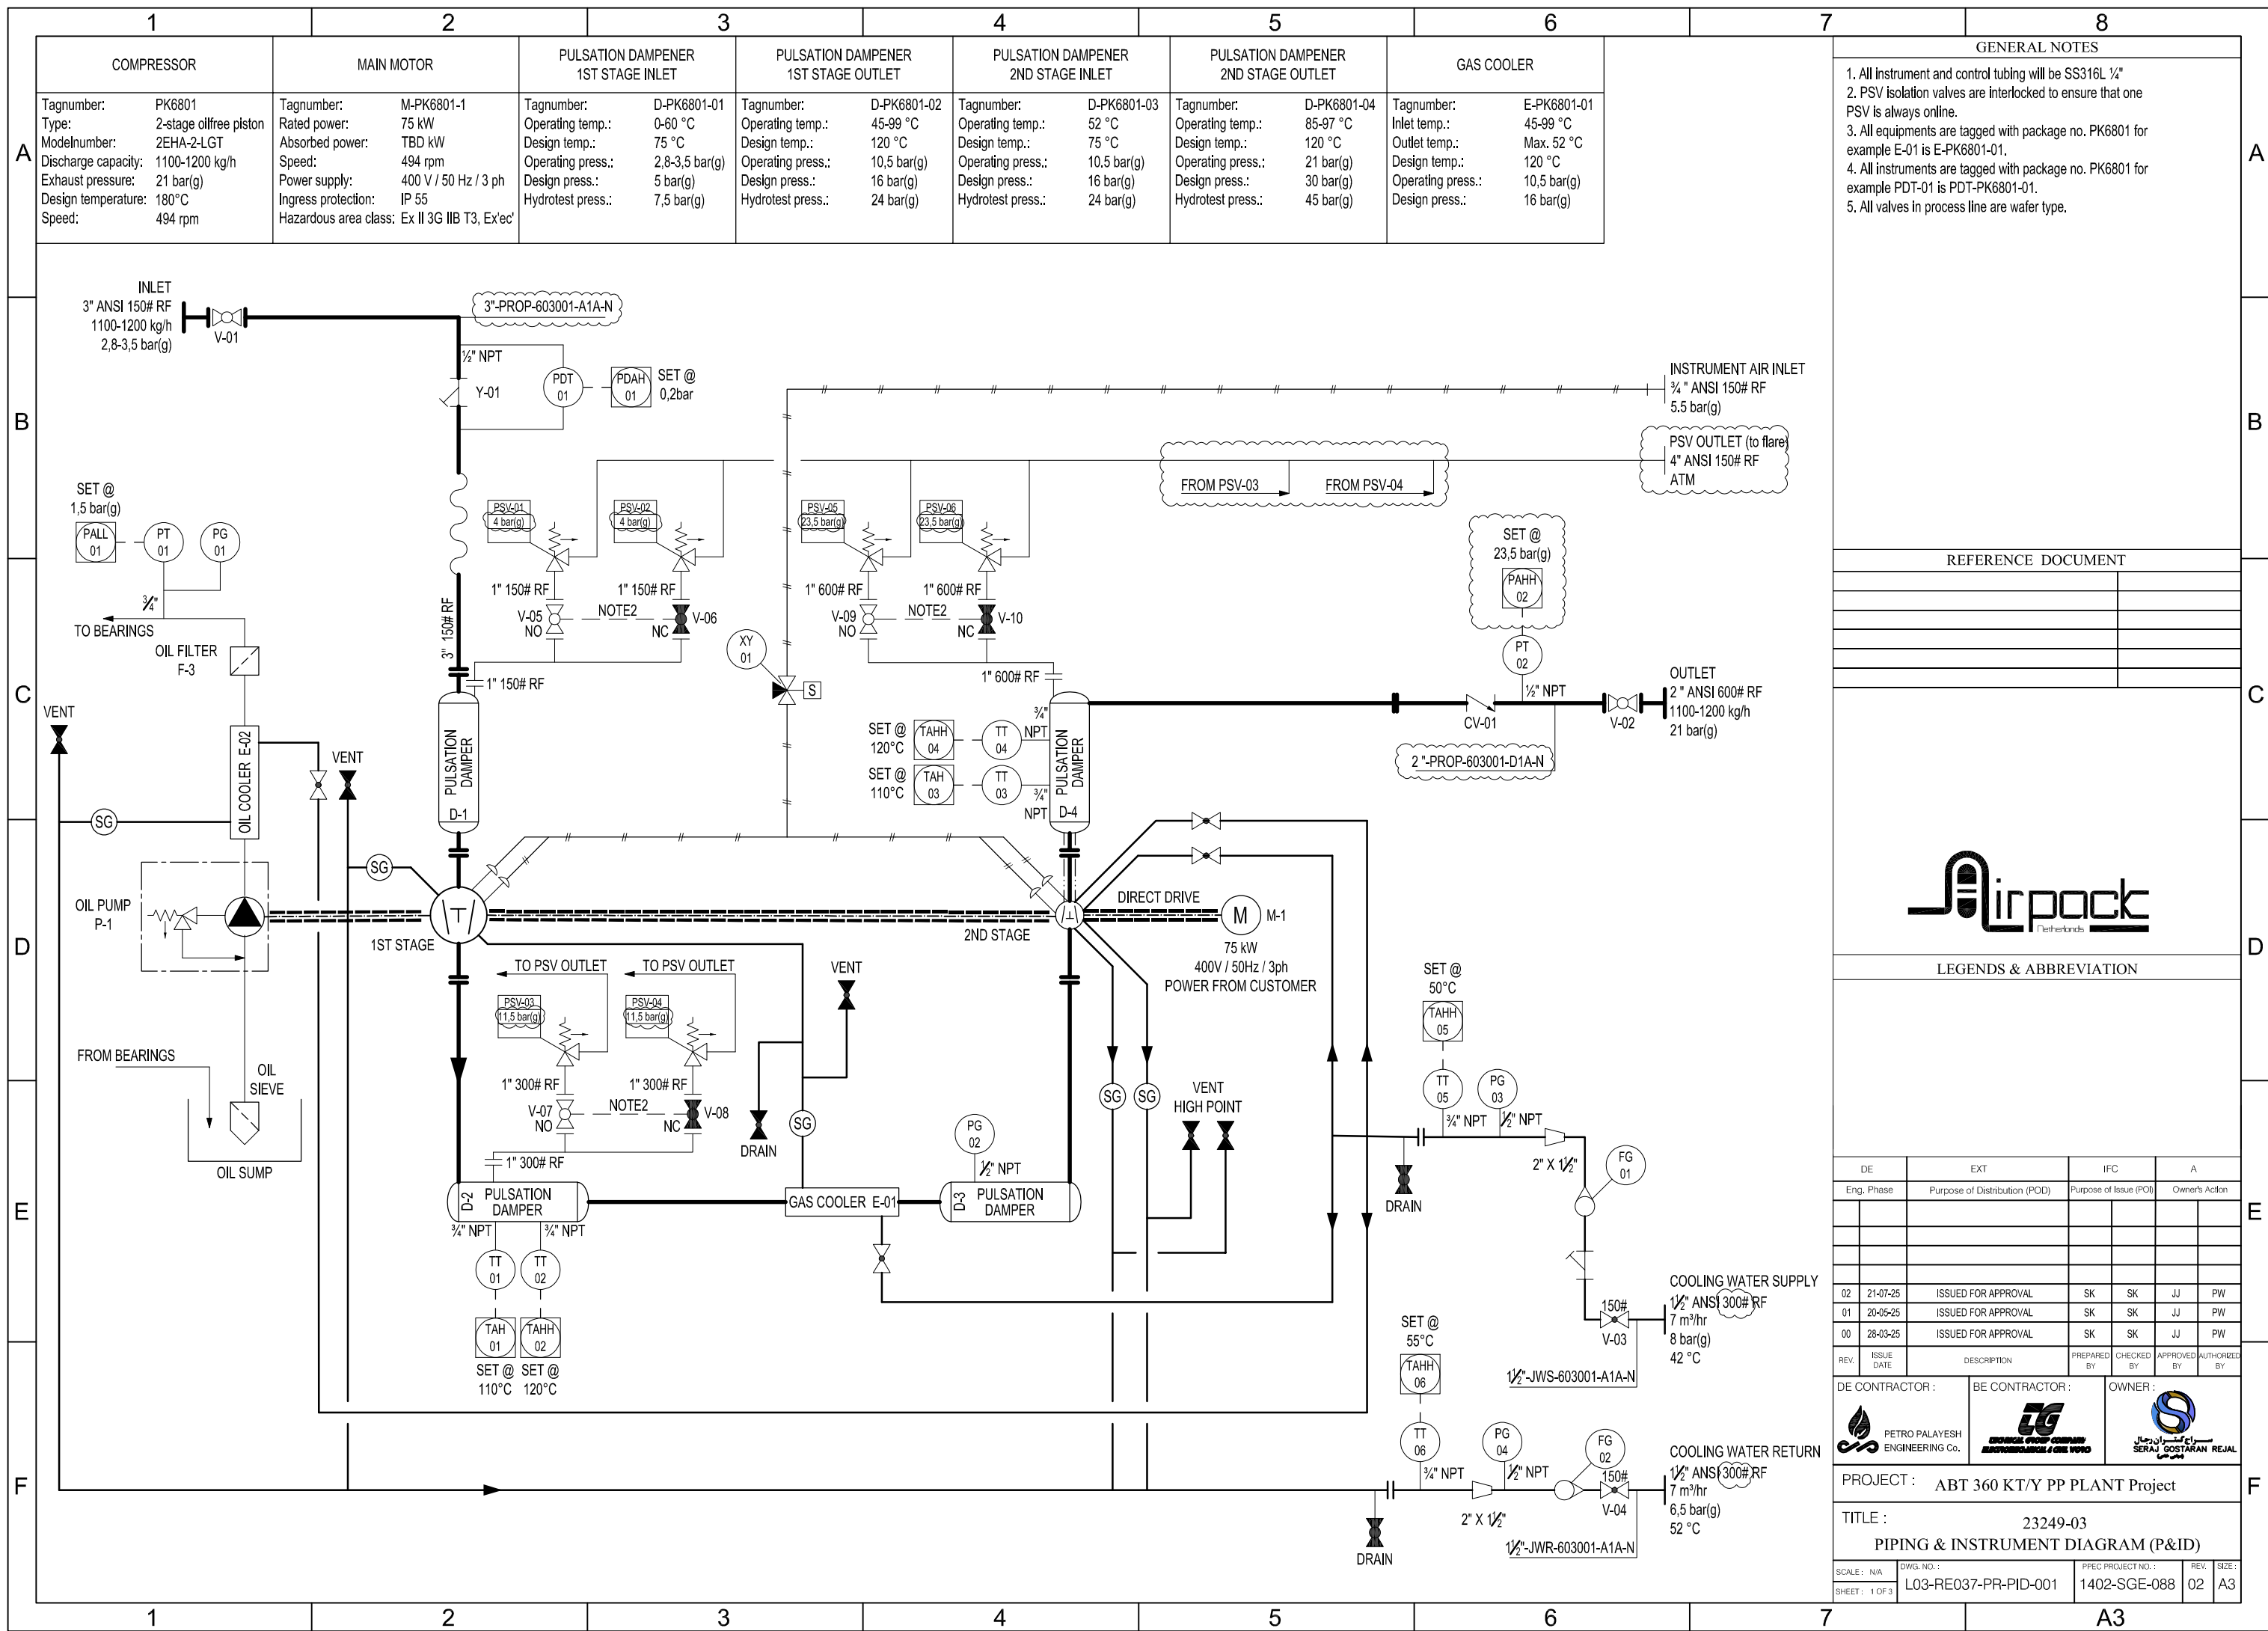

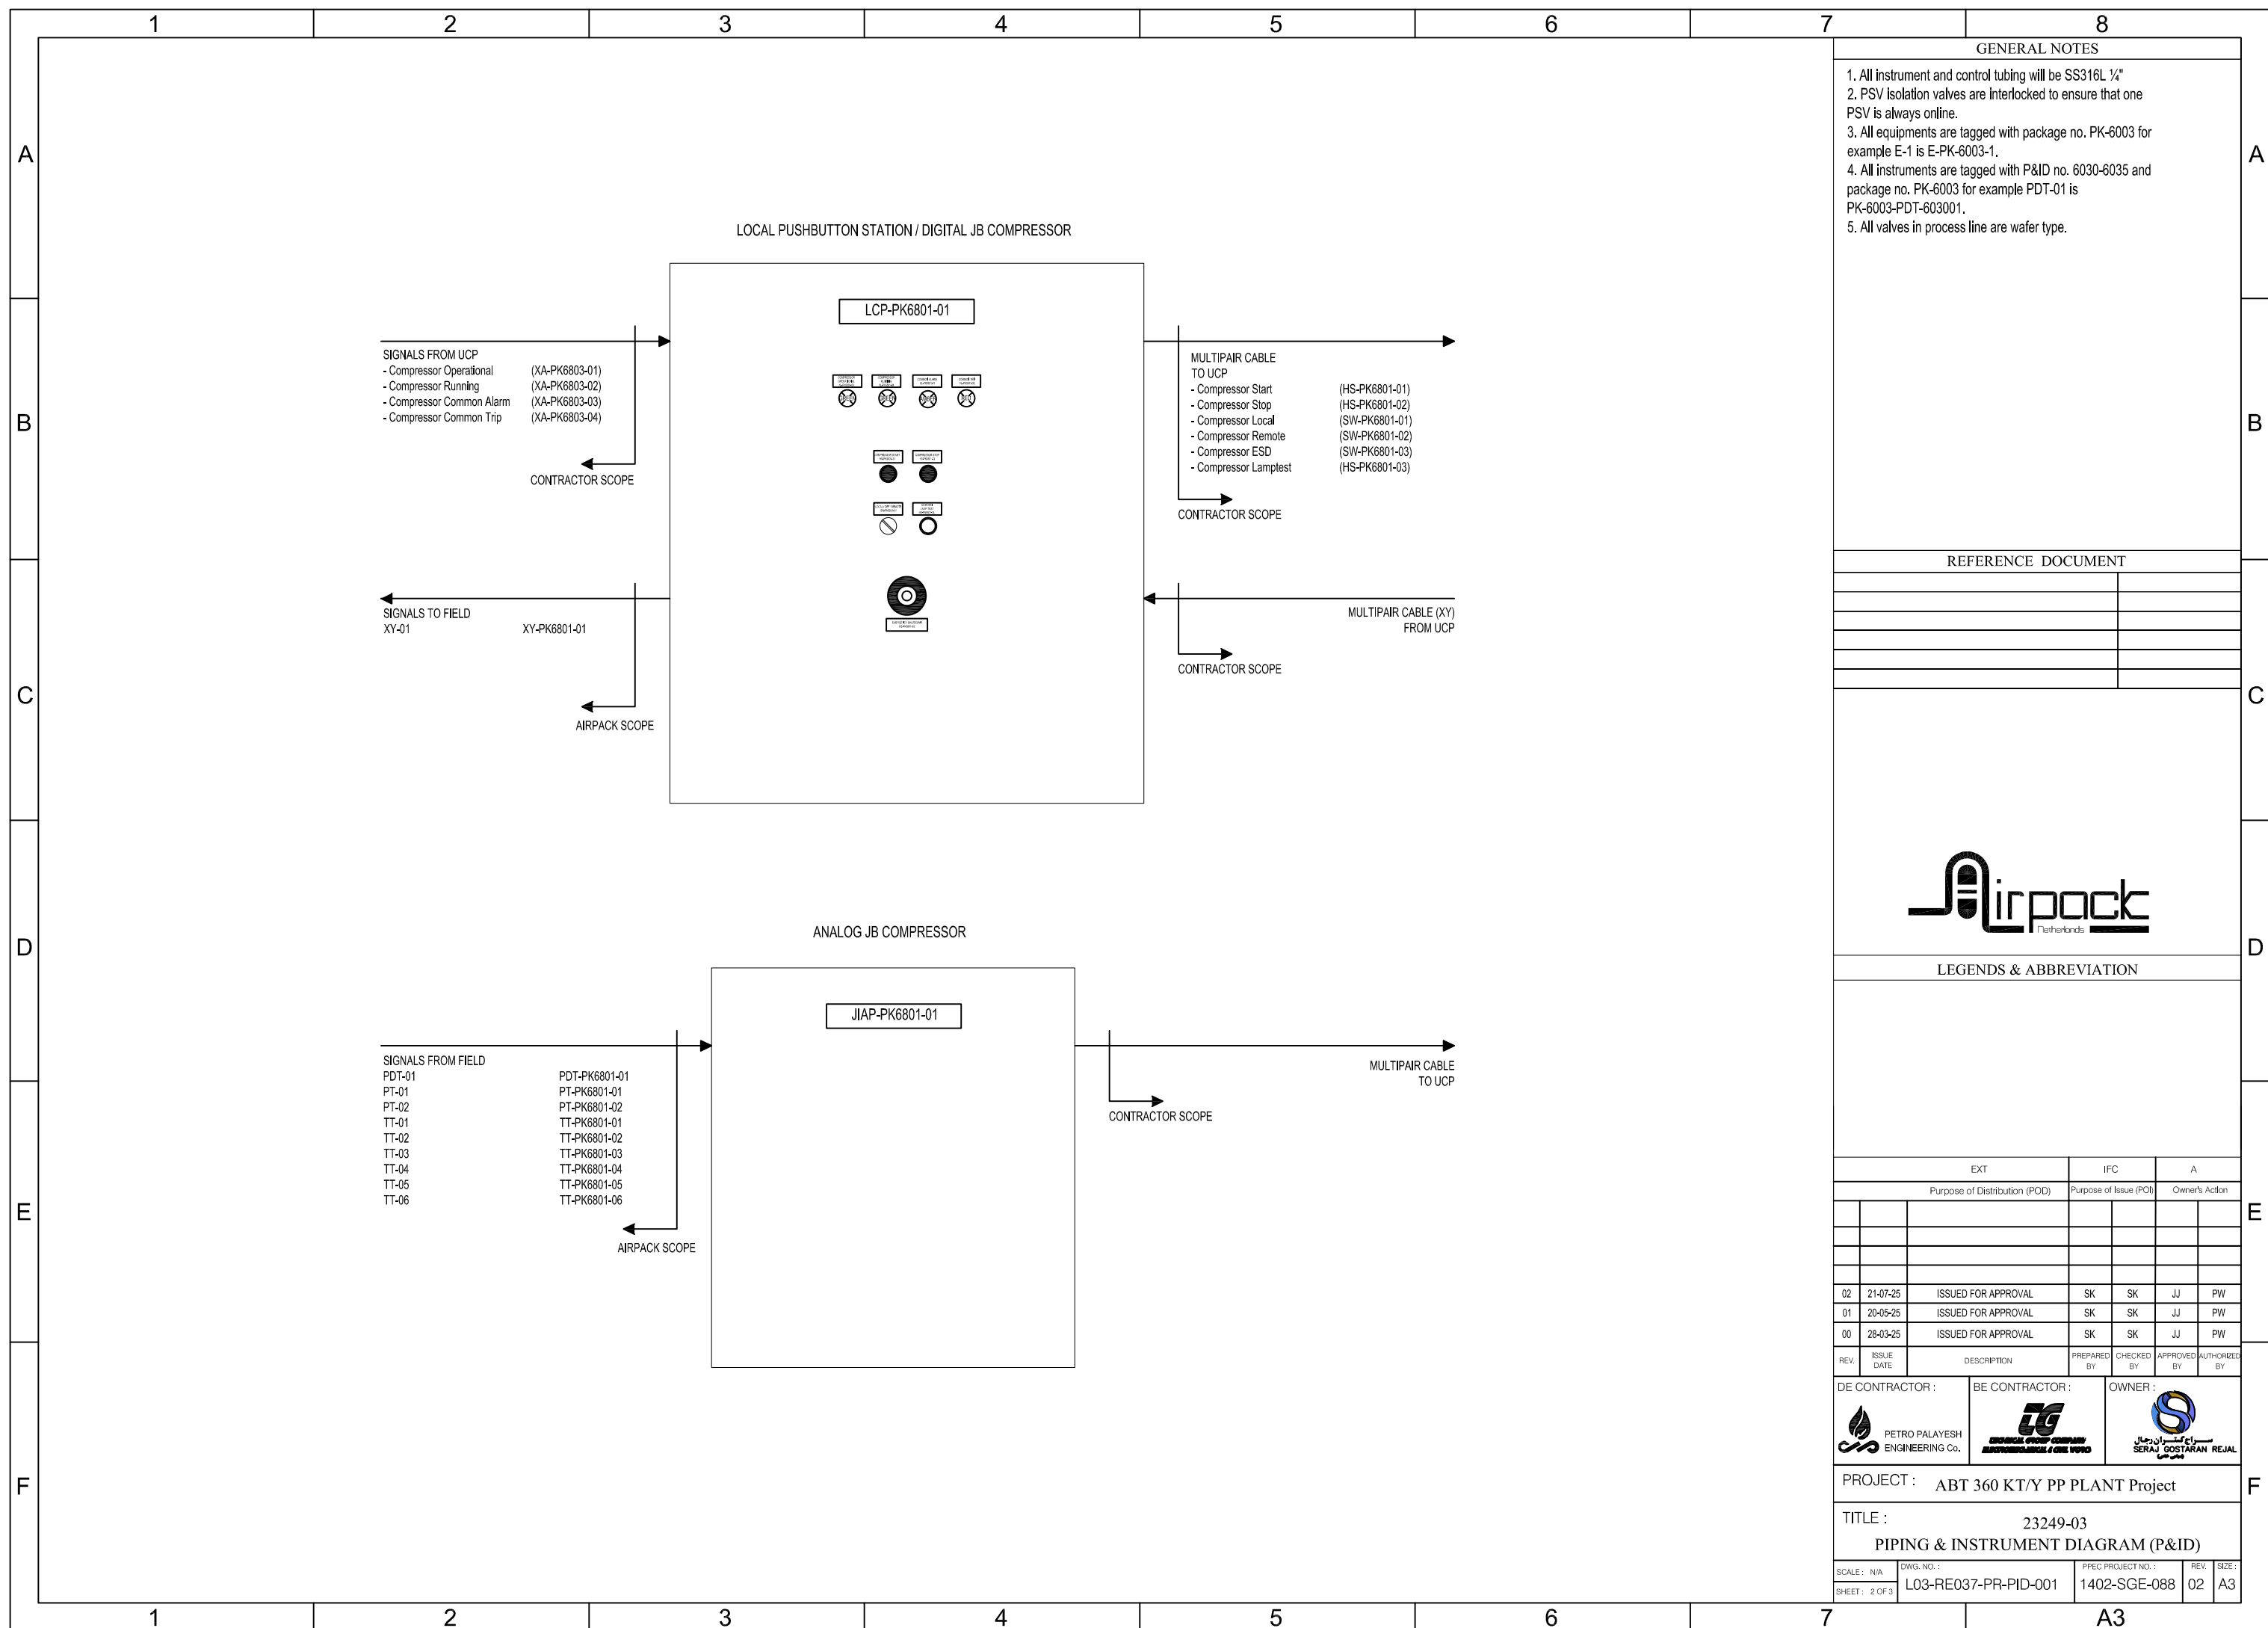

UNIT CONTROL PANEL COMPRESSOR

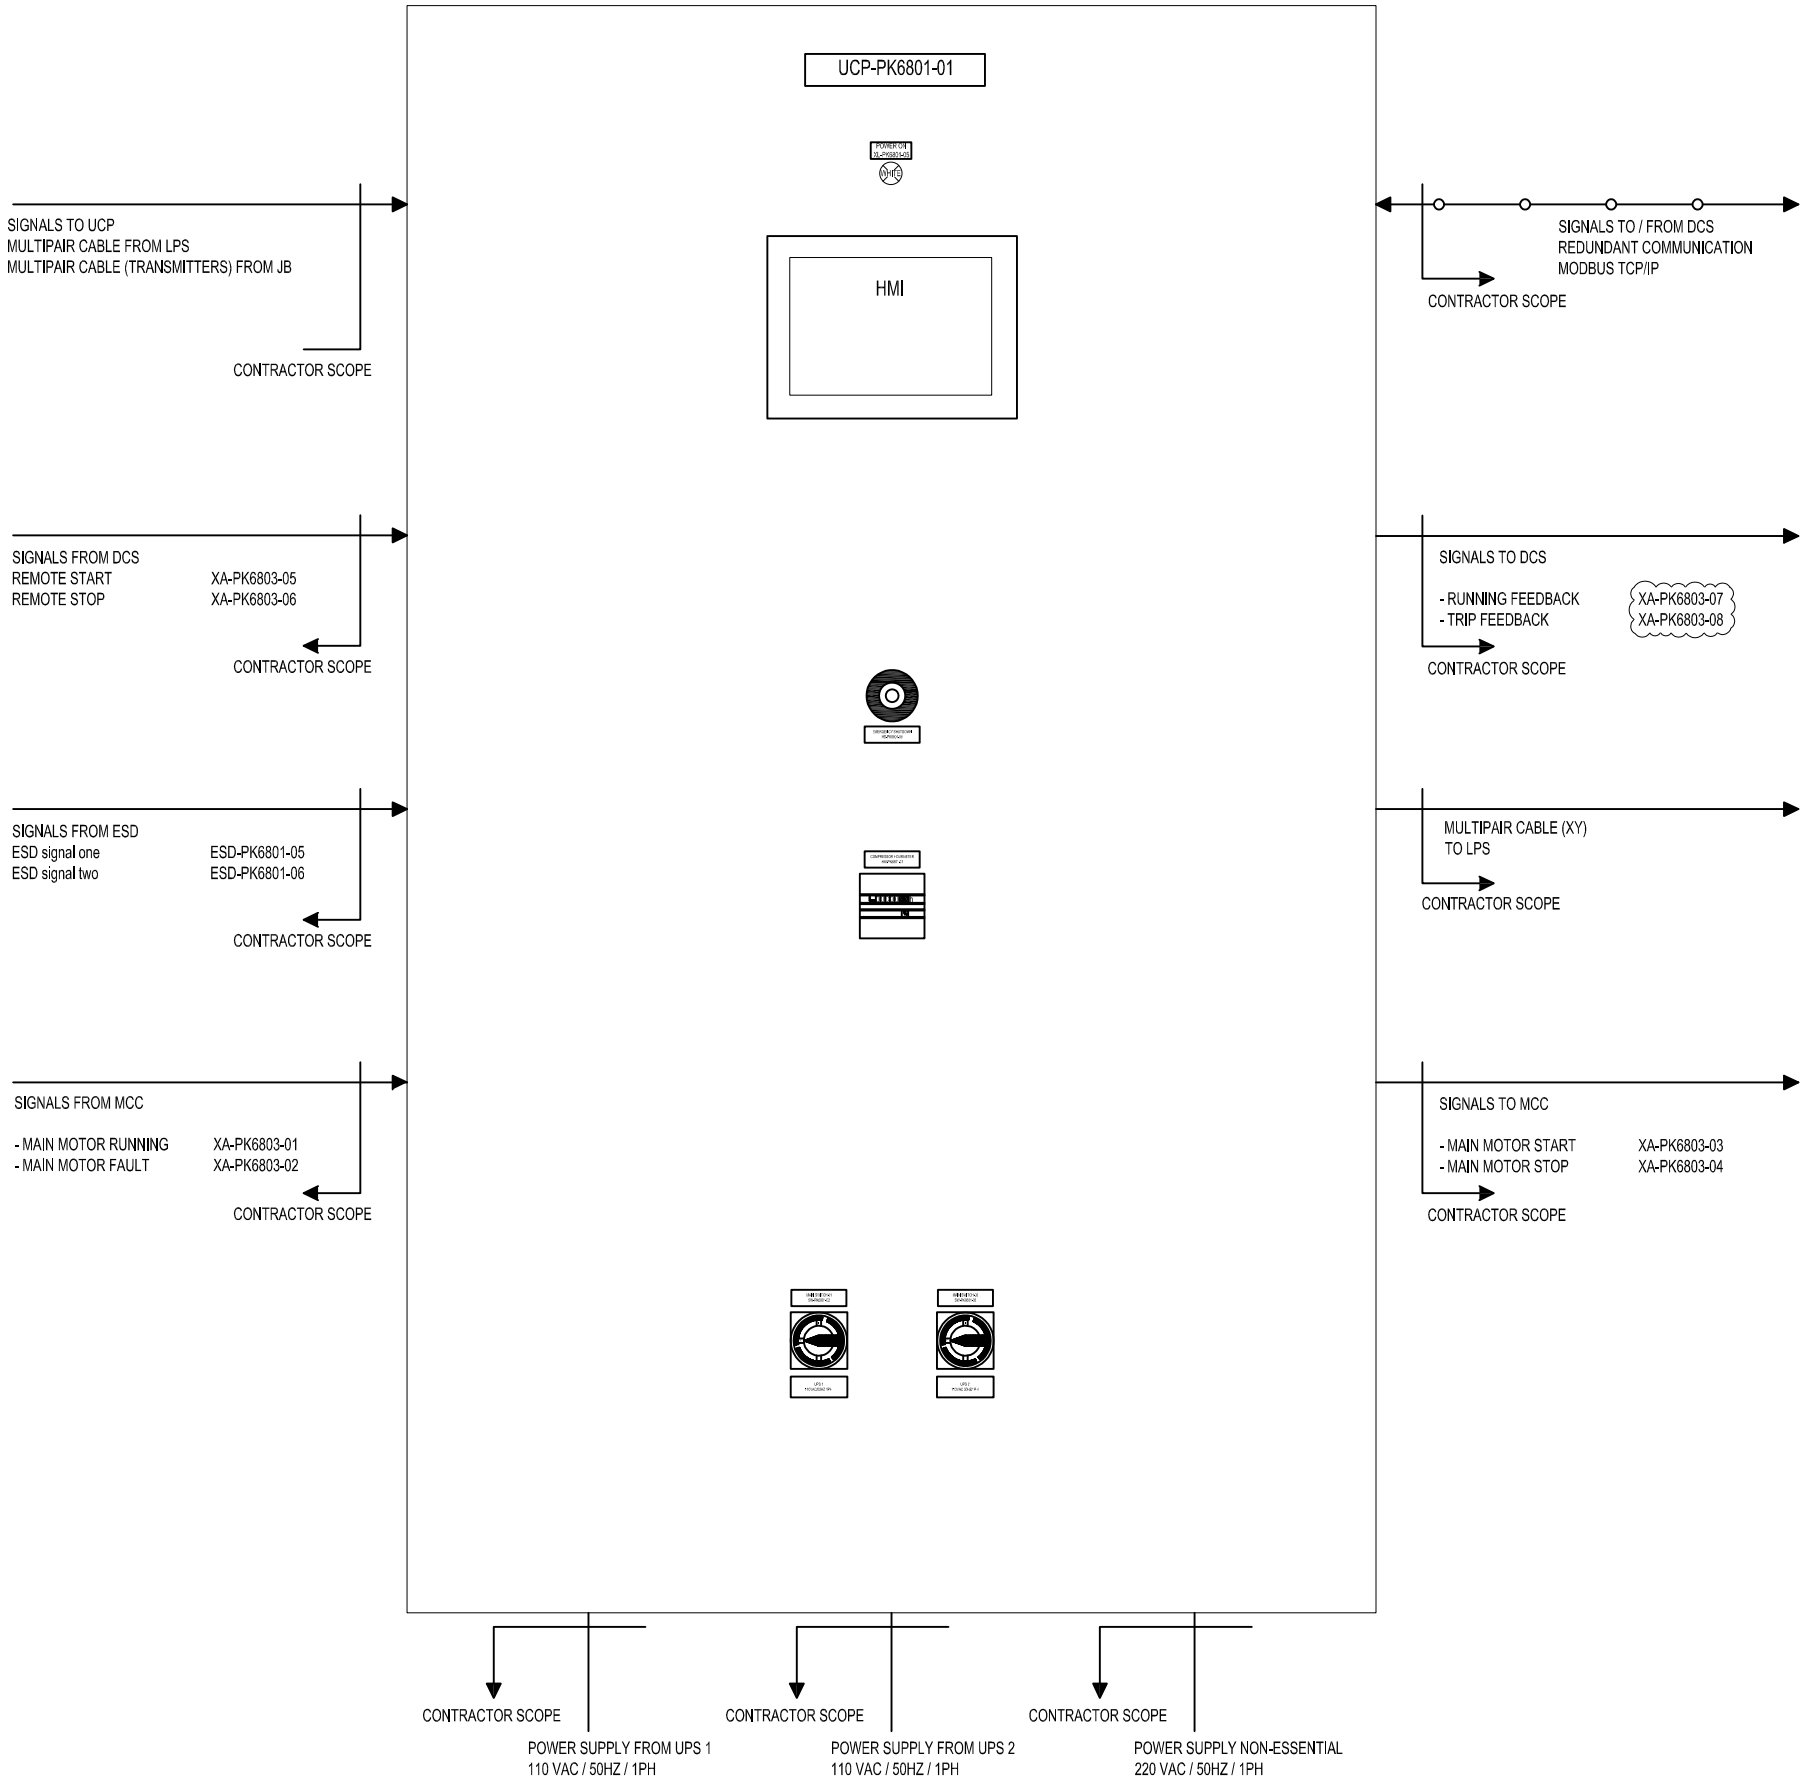

GENERAL NOTES

1. All instrument and control tubing will be SS316L 1/4"
2. PSV Isolation valves are interlocked to ensure that one PSV is always online.
3. All equipments are tagged with package no. PK-6003 for example E-1 is E-PK-6003-1.
4. All instruments are tagged with P&ID no. 6030-6035 and package no. PK-6003 for example PDT-01 is PK-6003-PDT-603001.
5. All valves in process line are wafer type.

REFERENCE DOCUMENT



LEGENDS & ABBREVIATION

EXT			IFC		A	
Purpose of Distribution (POD)			Purpose of Issue (POI)		Owner's Action	
02	21-07-25	ISSUED FOR APPROVAL	SK	SK	JJ	PW
01	20-05-25	ISSUED FOR APPROVAL	SK	SK	JJ	PW
00	28-03-25	ISSUED FOR APPROVAL	SK	SK	JJ	PW
REV.	DATE	DESCRIPTION	PREPARED BY	CHECKED BY	APPROVED BY	AUTHORIZED BY

DE CONTRACTOR :	BE CONTRACTOR :	OWNER :
 PETRO PALAYESH ENGINEERING CO.	 TECHNICAL GROUP COMPANY AUTOMATION, INSTRUMENTATION & CONTROL	 سراج گستران رجا SERAJ GOSTARAN REJAL

PROJECT : ABT 360 KT/Y PP PLANT Project

TITLE : 23249-03
PIPING & INSTRUMENT DIAGRAM (P&ID)

SCALE : N/A	DWG. NO. : L03-RE037-PR-PID-001	PPEC PROJECT NO. : 1402-SGE-088	REV. : 02	SIZE : A3
SHEET : 2 OF 3				